

KITCHEN & DINING SIZES REDUCED

LEGEND	
	SINGLE PLUG WITH HEIGHT INDICATED
	DOUBLE PLUG WITH HEIGHT INDICATED
	ISOLATOR
	WATER TIGHT SINGLE PLUG WITH HEIGHT INDICATED
	SATELITE CONNECTION POINT

ELECTRICAL LEGEND	
	DISTRIBUTION BOARD
	POWER SKIRTING
	3 POINT ELECTRICAL POWER SKIRTING SOCKET
	2 POINT ELECTRICAL POWER SKIRTING SOCKET
	3 POINT ELECTRICAL WALL SOCKET
	DOUBLE 3 POINT ELECTRICAL WALL SOCKET
	TELECOMMUNICATION POWER SKIRTING POINT
	TELECOMMUNICATION WALL SOCKET POINT
	TELECOMMUNICATION BOARD
	SMOKE DETECTION BOARD
	DOOR ALARM BOARD
	LIGHT SWITCH
	2 WAY LIGHT SWITCH

FIRE EQUIPMENT LEGEND	
	SMOKE DETECTOR AS PER FIRE ENGINEERS SPECIFICATION
	4.5kg DCP FIRE EXTINGUISHER AS PER FIRE ENGINEERS SPECIFICATION
	30M FIRE HOSE REEL AS PER FIRE ENGINEERS SPECIFICATION
	FIRE ESCAPE

NOTES:

GENERAL

ALL LEVELS, DIMENSIONS AND POSITIONS TO BE CHECKED AND VERIFIED BEFORE ANY WORK IS COMMENCED. ANY ERRORS, DISCREPANCIES OR OMISSIONS TO BE REPORTED TO THE ARCHITECT IMMEDIATELY.

ALL WORK TO BE IN ACCORDANCE WITH GOOD AND ACCEPTED LOCAL BUILDING PRACTICE. FIGURED DIMENSIONS TO BE TAKEN IN PREFERENCE TO SCALED DIMENSIONS.

THESE DRAWINGS TO BE READ IN ACCORDANCE WITH ENGINEERS AND CONSULTANT DRAWINGS. ALL BUILDING BY-LAWS, HEALTH AND FIRE REQUIREMENTS TO BE STRICTLY ADHERED TO.

THE CONTRACTOR WILL BE RESPONSIBLE FOR THE CORRECT SETTING OUT OF THE WORK ANY DOUBT AS TO THE ACCURACY OF BOUNDARY PEGS OR LINES TO BE REPORTED TO THE ARCHITECT IMMEDIATELY.

FOUNDATION TO BOUNDARY WALLS NOT TO ENCRoACH OVER BOUNDARY LINES

ALL ELECTRICAL AND DRAINAGE WORK TO BE EXECUTED BY REGISTERED TRADESMEN.

LINTOLS TO BE INSTALLED IN ACCORDANCE WITH MANUFACTURER'S INSTRUCTIONS.

BRICKFORCE REINFORCING TO BE INSTALLED IN SUBSTRUCTURE BRICKWORK EVERY FIVE COARSE.

ANT POISONING UNDER ALL SURFACE BEDS.

CONTRACTOR SHALL TAKE ALL NECESSARY PRECAUTION TO AVOID ANY DAMAGE WHATSOEVER TO EXISTING BUILDINGS AND FENCES.

D.P.C. TO ALL WINDOW SILLS AND UNDER SURFACE BEDS UNDER SUPER STRUCTURE WALLS.

GLAZING:
AS PER SCHEDULE

DRAINAGE:
ALL SOIL PIPES UNDER BUILDINGS OR FOOTINGS TO BE ENCASED IN CONCRETE OF MIN. 100mm THICKNESS ALL AROUND PIPE.

INSPECTION EYES AT ALL BENDS AND JUNCTIONS OF DRAINS, WITH MARKED COVERS AT GROUND LEVEL.

ALL WASTE PIPES TO BE ACCESSIBLE OVER THE ENTIRE LENGTH.

NO DRAINAGE BENDS OR JUNCTIONS IN OR UNDER FLOORS.

PROVIDE JETS AT EACH END OF ENCASED DRAIN WHERE SAME PASSES UNDERNEATH THE BUILDING AS NEAREST POSSIBLE TO FOUNDATION.

RESEALING TRAPS TO ALL WASTE WATER FITTINGS

WASTE PIPES ON SINGLE PIPE SYSTEM WILL BE FITTED WITH 65mm DEEP SEAL TRAPS AND EACH FITTING WILL BE ANTI-SYPHONED.

W.C. SOIL PIPES HAVING A GREATER DEPTH FROM PAN TO PIPE INVERT LEVEL OF 1.230m WILL BE ANTI-SYPHONED.

WASTE PIPES UNDER FLOORS TO BE SLEEVED.

MIN. FALL OF 100mm DRAINS TO BE 1:60, 300mm MIN. COVER.

WASTE PIPES TO BASIN TO BE MIN. D32mm AND TO ALL OTHER FIXTURES D40 mm.

THE SHEET AND ALL DRAWINGS SHOWN HEREIN ARE THE COPYRIGHT OF JEREMIE MALAN ARCHITECTS AND INTERIORS CC AND IS NOT TO BE USED FOR ANY PURPOSE WHATSOEVER WITHOUT THE WRITTEN APPROVAL OF JEREMIE MALAN ARCHITECTS AND INTERIORS CC.

REVISION RECORD / WYSIGINGSREKORD		
REV. NO.	DATE	DESCRIPTION
A	2015-08-07	ISSUE TO CLIENT



JEREMIE MALAN
architects • interiors

273 Tram Street Nieuw Muckleneuk Pretoria
P.O. Box 2396
Brooklyn Square, 0075
Tel: (012) 460 5388
Fax: (012) 346 7447
malanarc@mweb.co.za
www.malanarchitects.co.za


J. MALAN SACAP REG. NO. 3950 MIA. 5013 PIA. MAO422 SAIA. MA2341

CLIENT/CLIENT: **SOUTH AFRICAN NATIONAL PARKS**

PROJECT/PROJEK: **NEW HOSTELS FOR MAPUNGBWE NATIONAL PARK**

DRAWING/TEKENING: **DINING BLOCK POWER LAYOUT PLAN**

DATE / DATUM: 2015-06-22	PROJECT No.: 521	DRAWING No. / TEKENING No.: 103	REVISION: A
DRAWN / GETEKEN: DR	SCALE / SKAAL: 1:100		

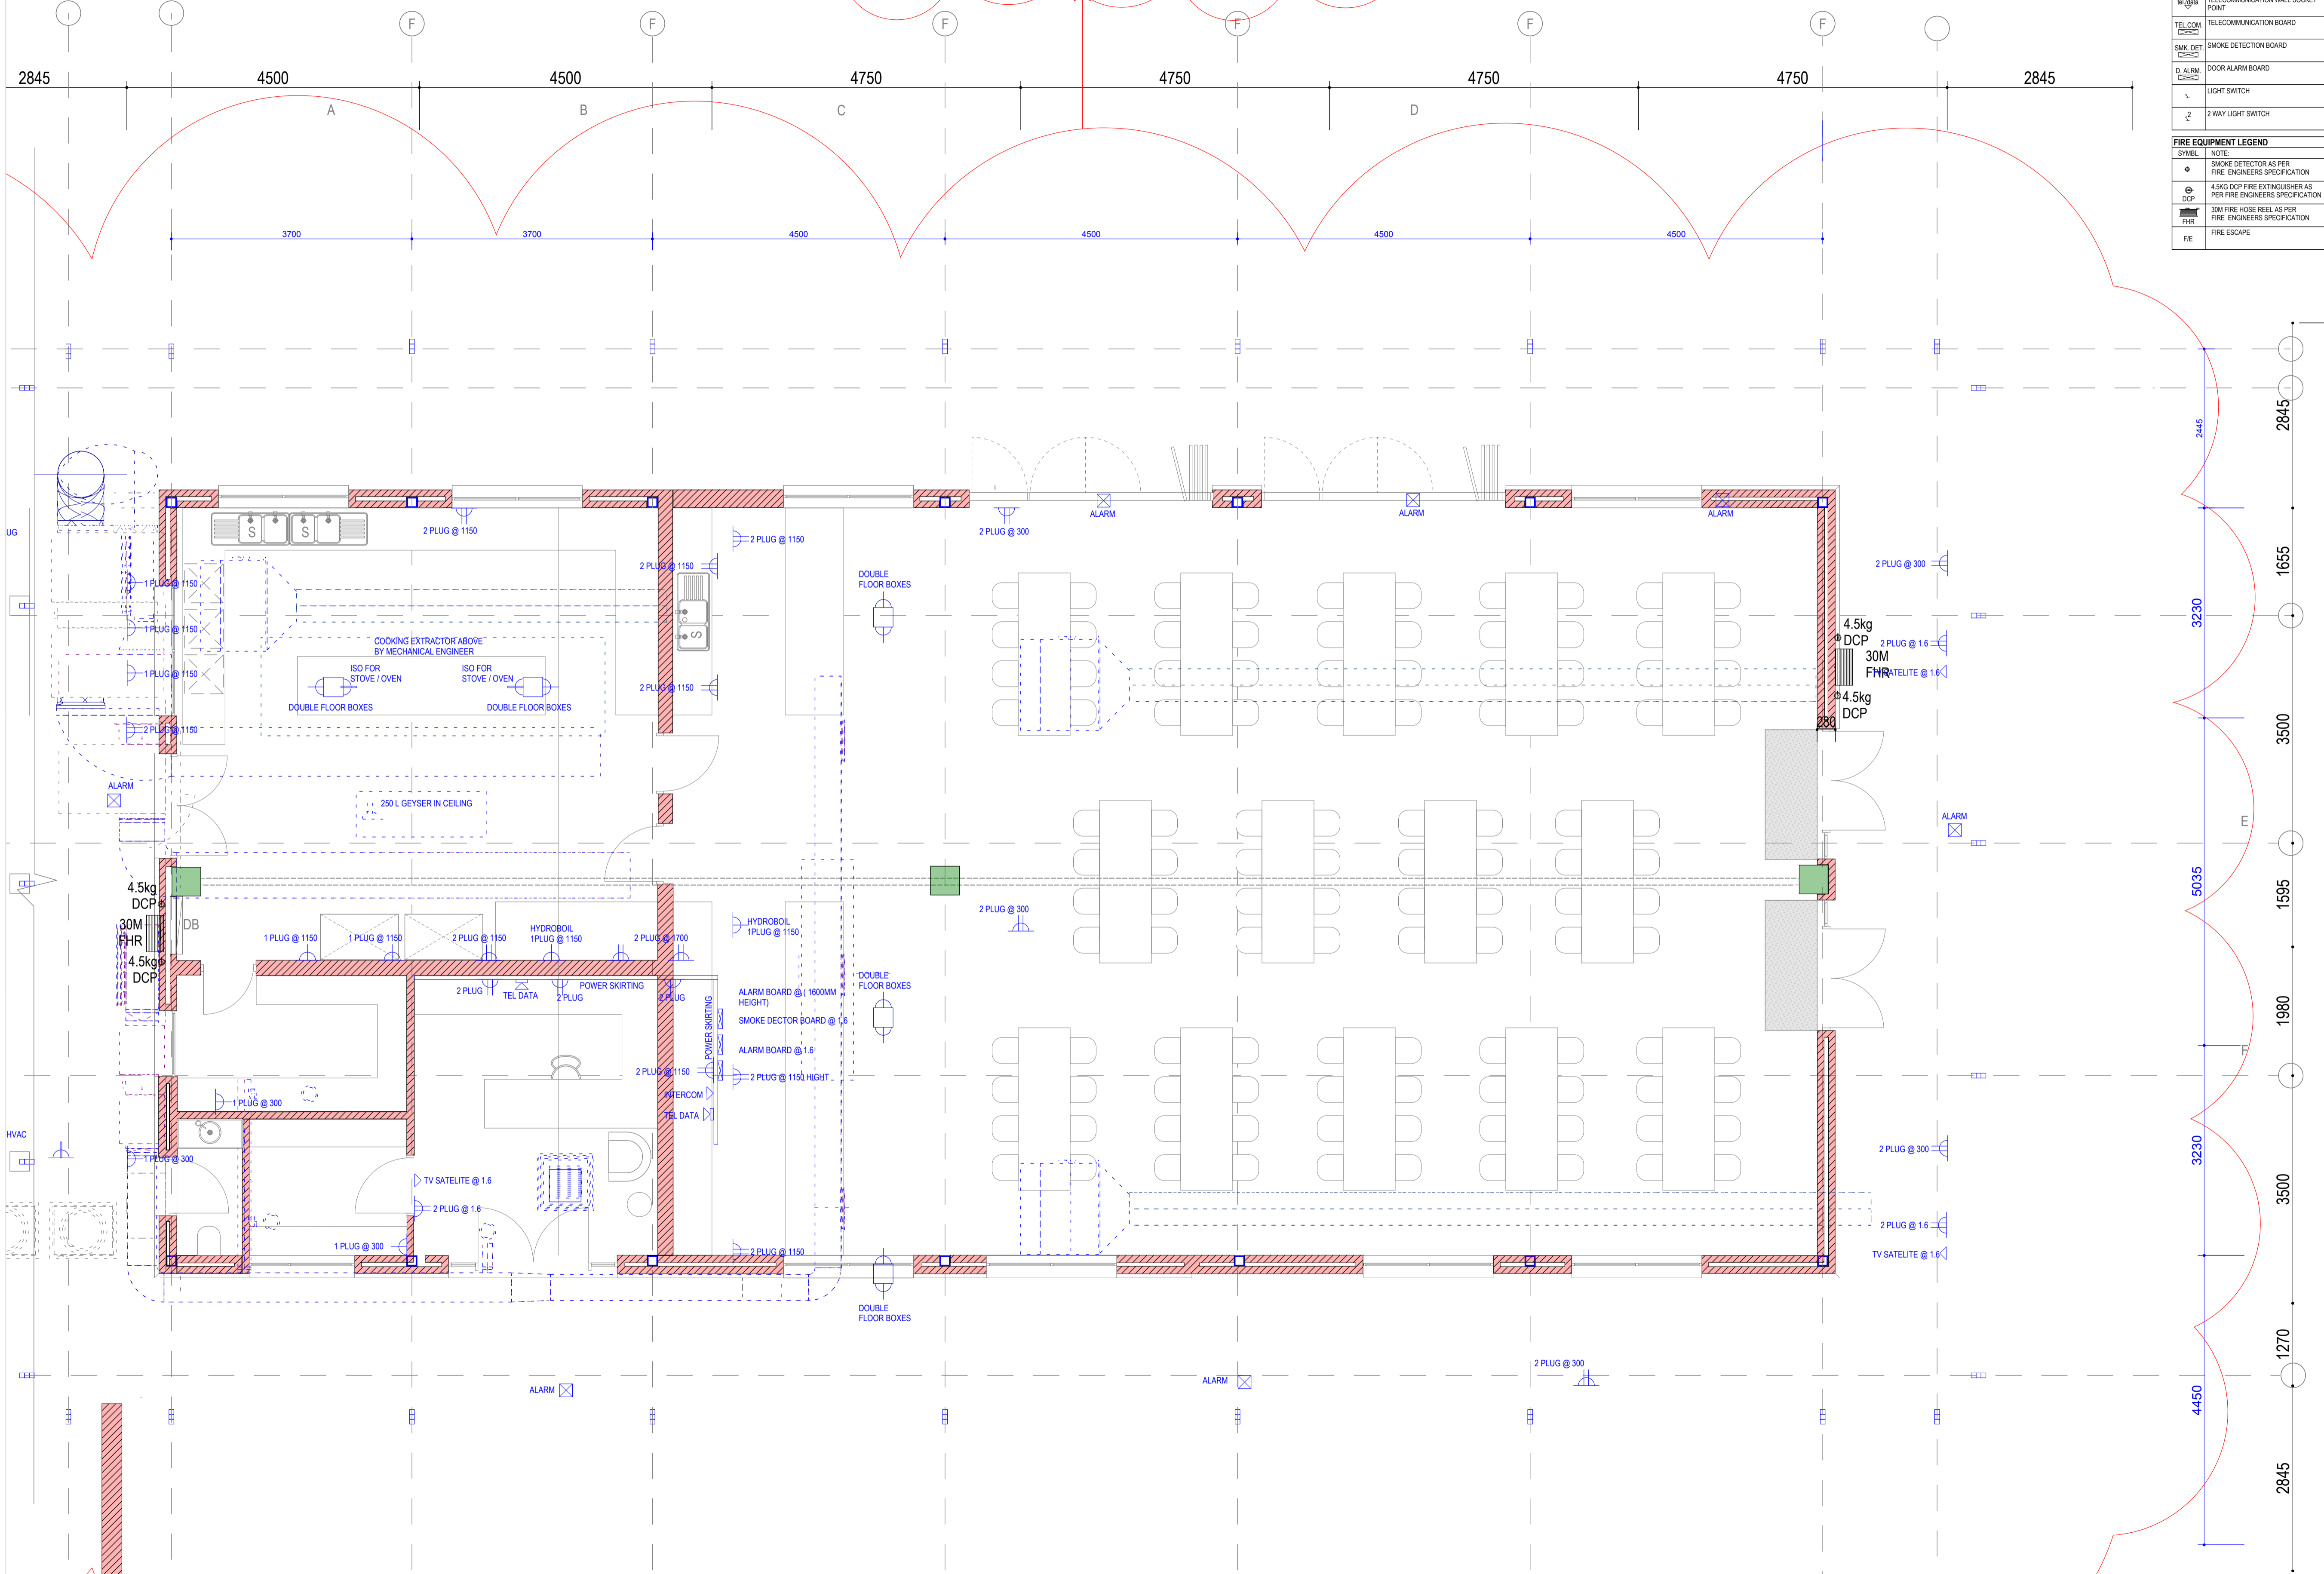

DINING BLOCK POWER LAYOUT PLAN _ see DRAWING NO 104 FOR CONTINUATION OF YARD AREA _ POWER LAYOUT PLAN

SCALE 1:50