





193 Watsonia Rd.

249710

PROPOSED SEWER DRAINAGE LAYOUT FOR H.D. JOSHUA
ON SUB 6 OF 134 OF CLARK OF WENTWORTH 860 193 WATSONIA RD

DRAWN BY *J.B. Proulx*
Bit out

SHEET	COPY
1/1	3
CITY OF DURBAN	
PLAN NO. 839/6/78	
APPROVED	DATE
R.E. MACLEOD	25 JUL 1978
CITY APPROVED FOR	

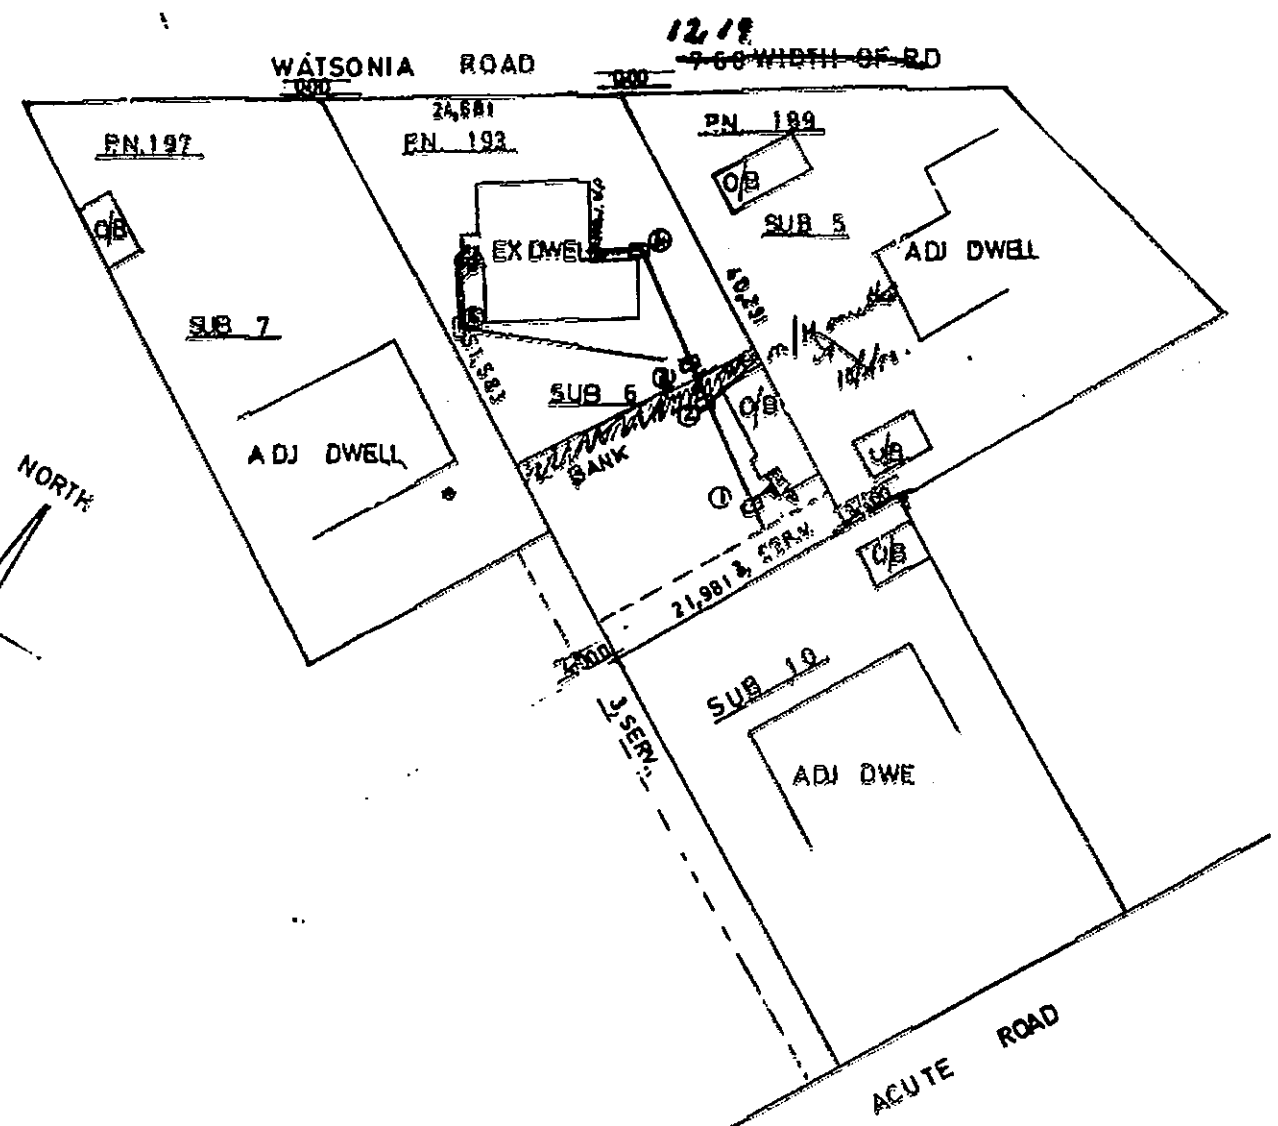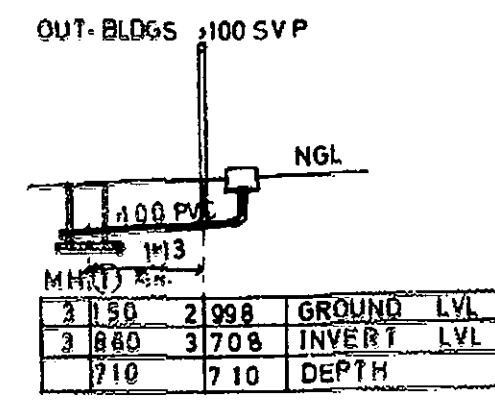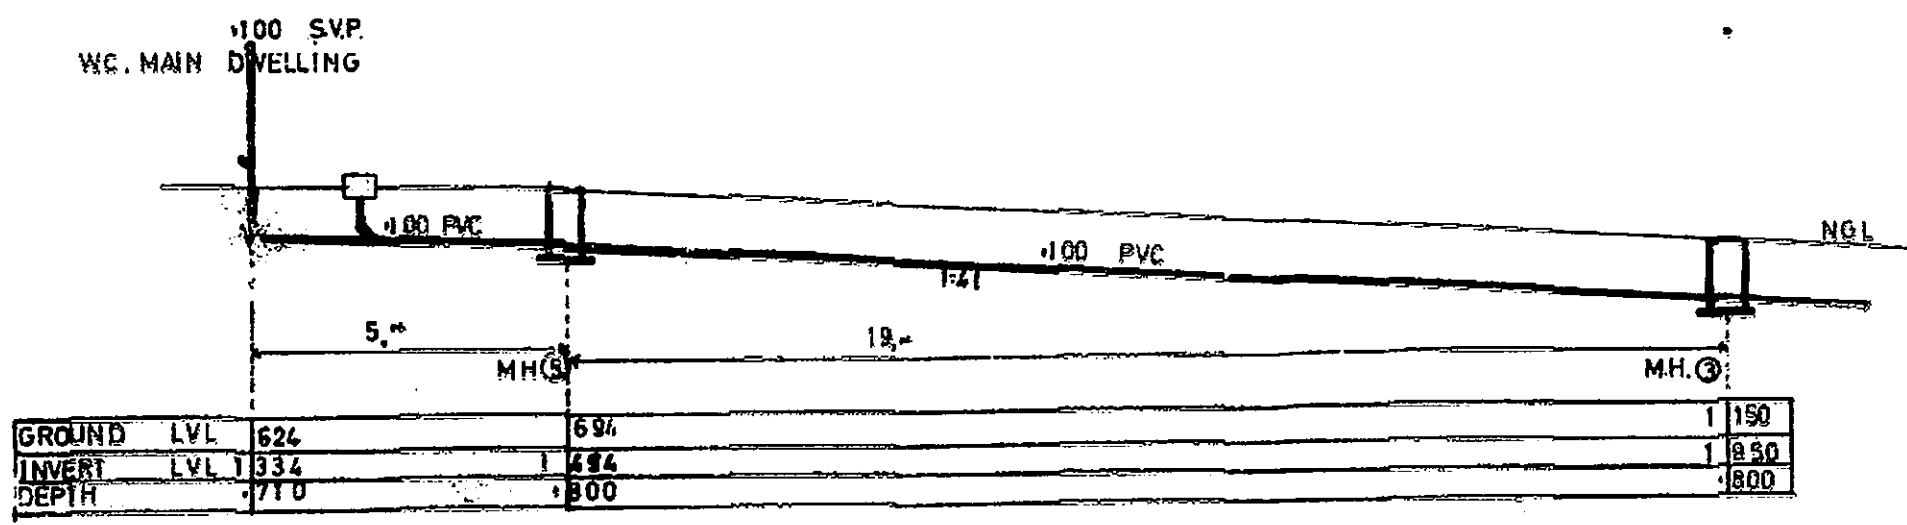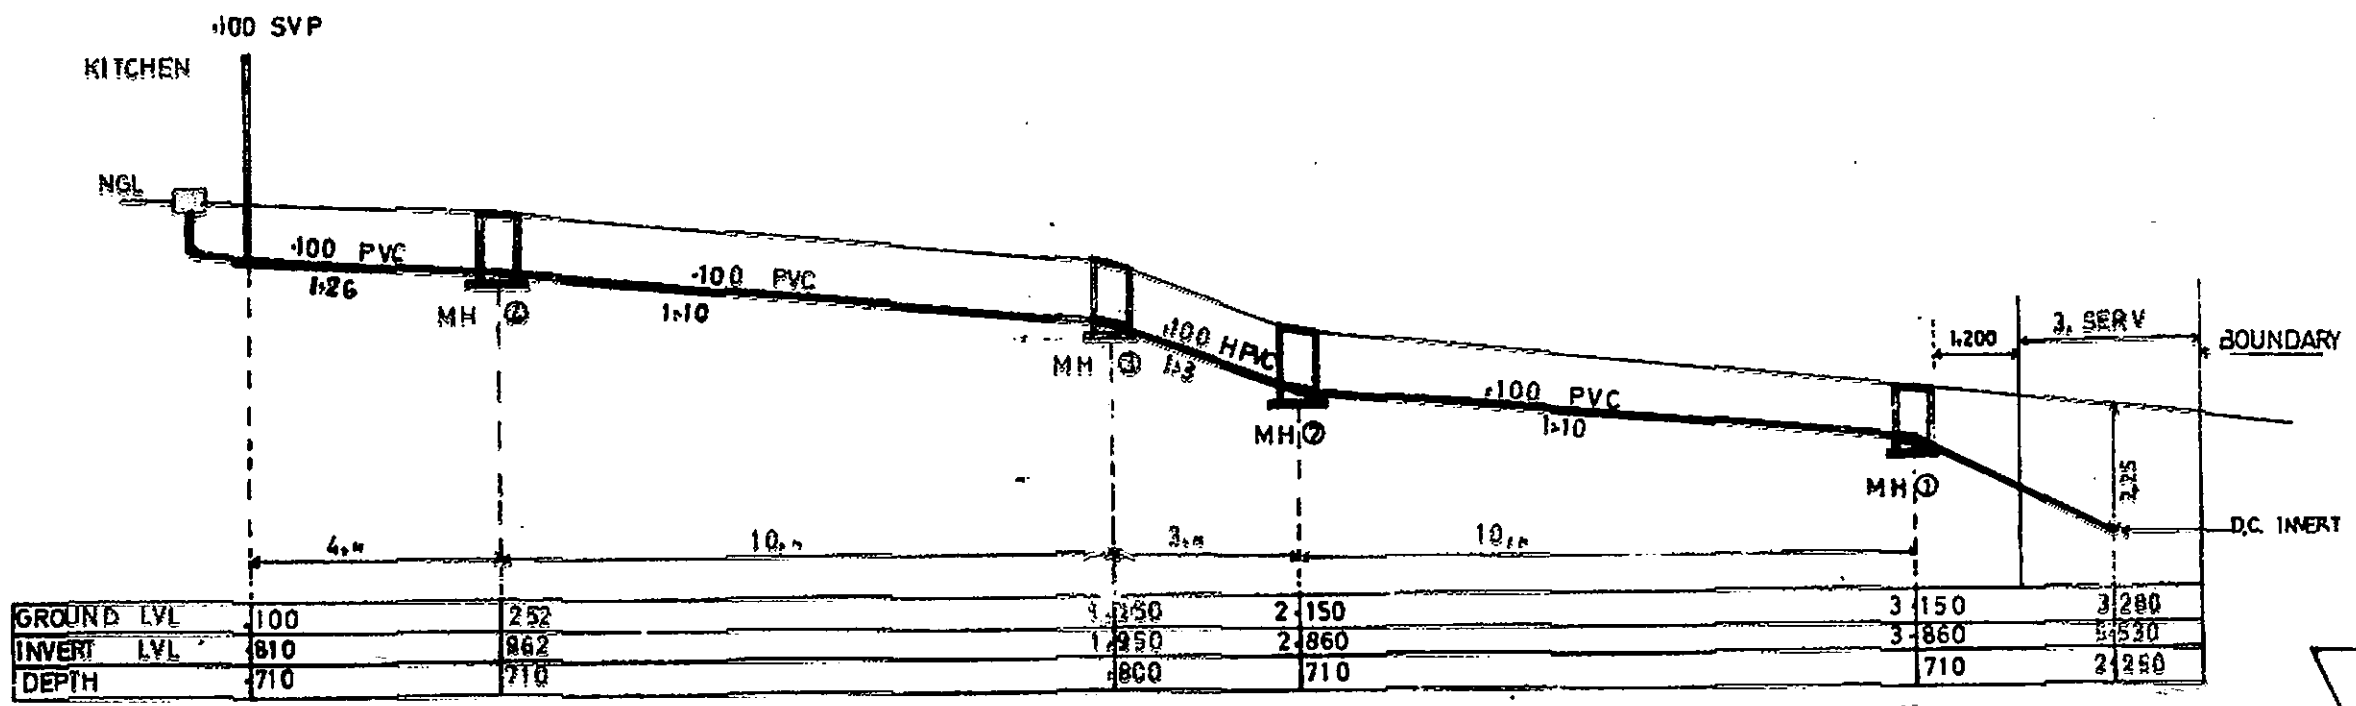

All existing wastes, drains, soil & vent pipes to conform to current By-Laws.

ORIGINAL AS BUILT
18/8/78