

SEWERAGE SECTION
SCALE 1:100

DATE	15.2	300
DEPTH	1.505	1.480
PIPE	100	75
MAN. HOLES	100	2.750
MAN. HOLES	100	1.500
MAN. HOLES	100	1.500


SHEET 1/1 COPY 3

CITY OF DURBAN
PLAN NO. 803/10/73



APPROVED
C. G. HANDS
CITY ENGINEER

28 NOV 1973
1048

All existing wastes, drains, soil & vent pipes to conform to current By-Laws.

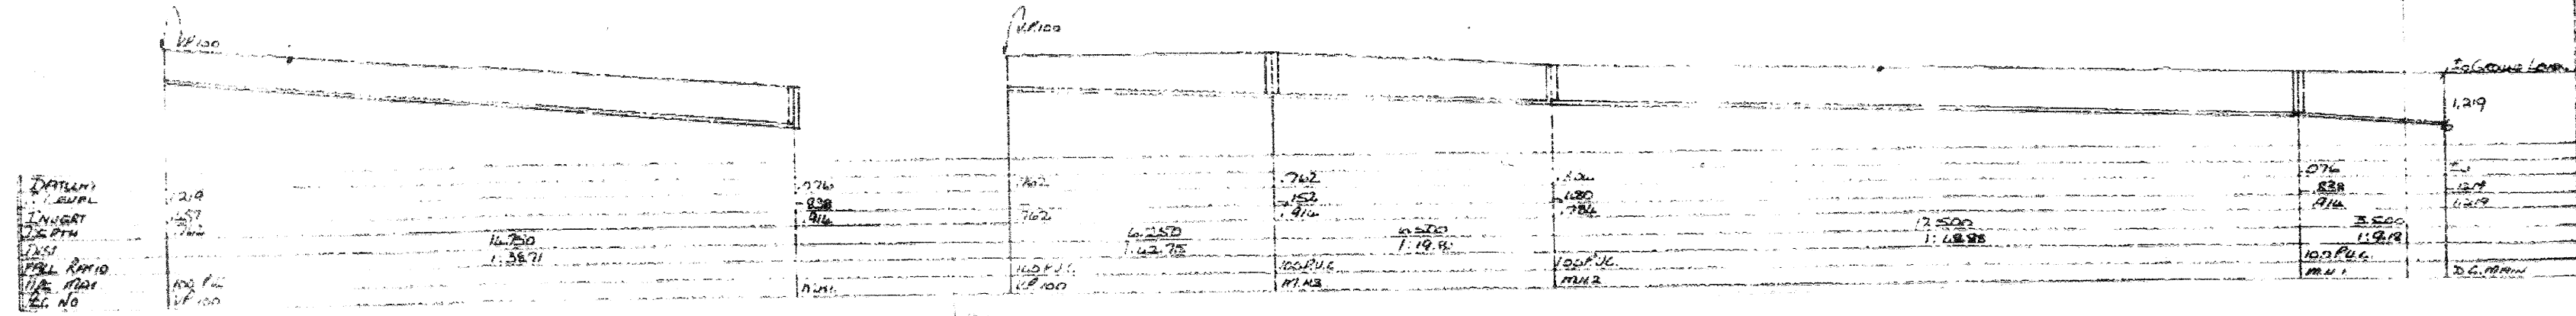

SITE PLAN
SCALE 1:200

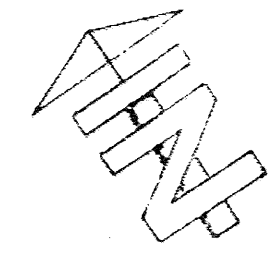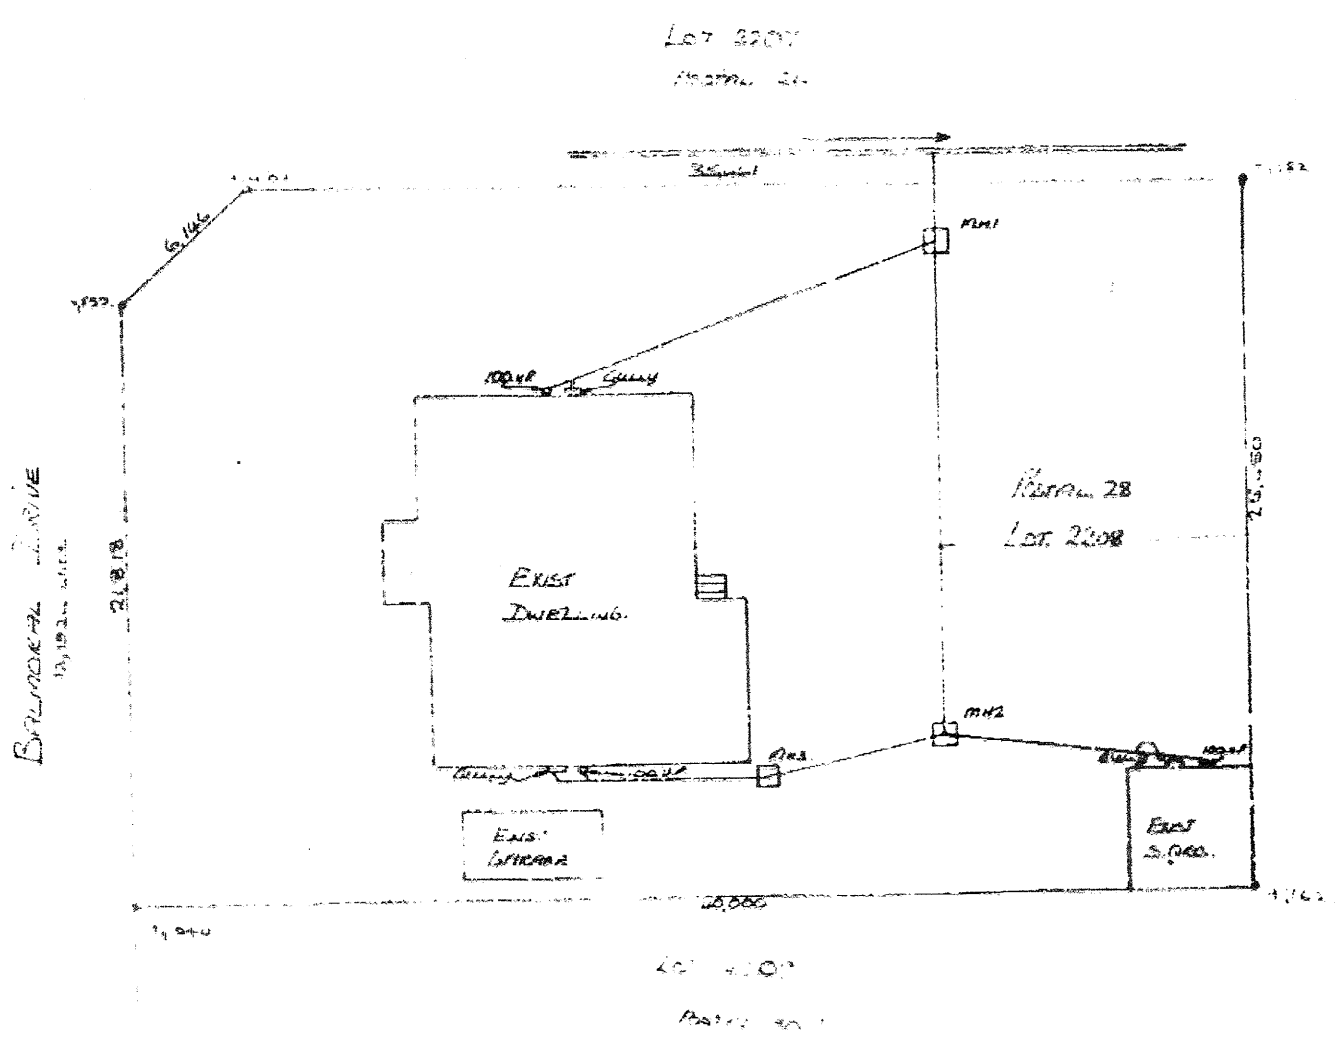

28, Balmoral Ave
Sewer L/Out

PROPOSED SEWERAGE LAYOUT FOR
MR. J. KEMP AT 28 BALMORAL DRIVE,
ON LOT 2208 OF 13 OF VICTORIA
COUNTY.

PREPARED BY: DESIGN & PLAN CENTRE
112, ROSA HOUSE
332 WEST STREET
DURBAN, PHONE 67558

DRAWN BY: [Signature]

CHECKED BY: [Signature]

SIGNATURE: [Signature] DATE: 19.7.73