




SEWER SECTION FROM KITCHEN TO M.H. 3. scale 1:200

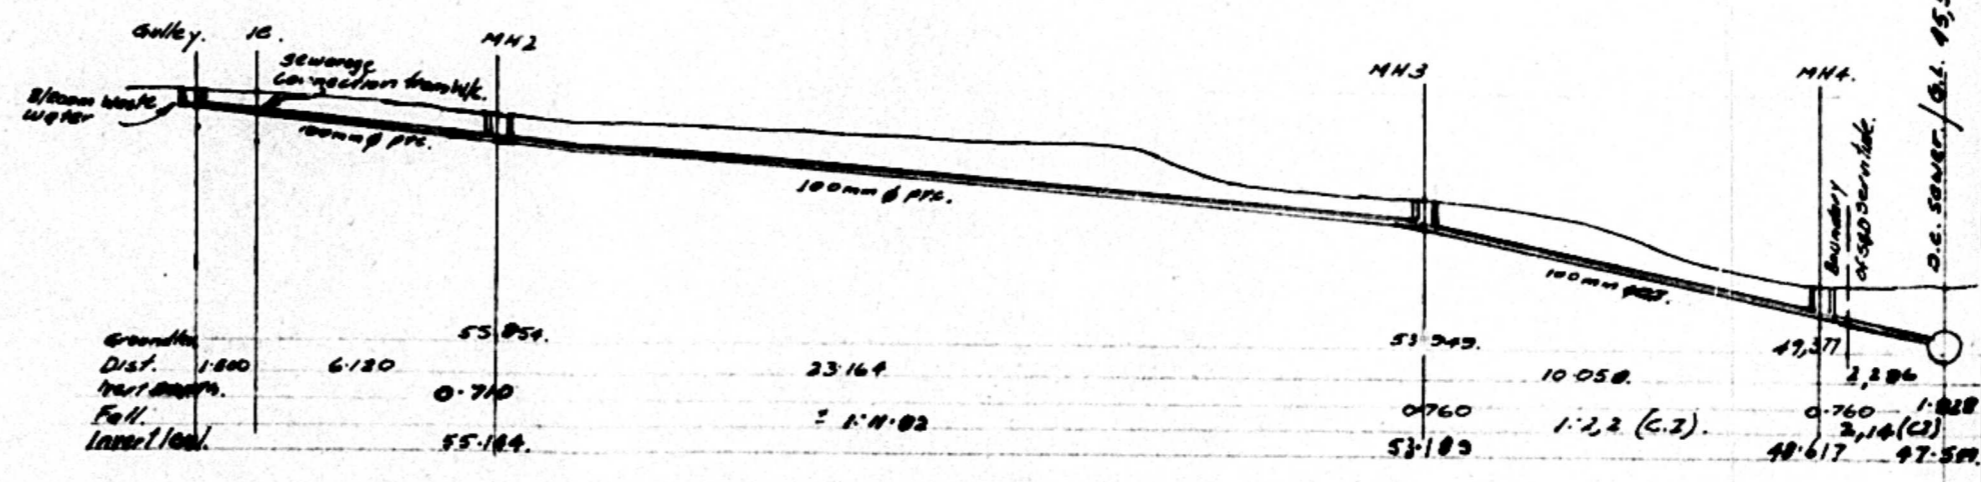

SEWER SECTION FROM B/ROOM & W.C. TO CORP. MAIN. scale 1:200

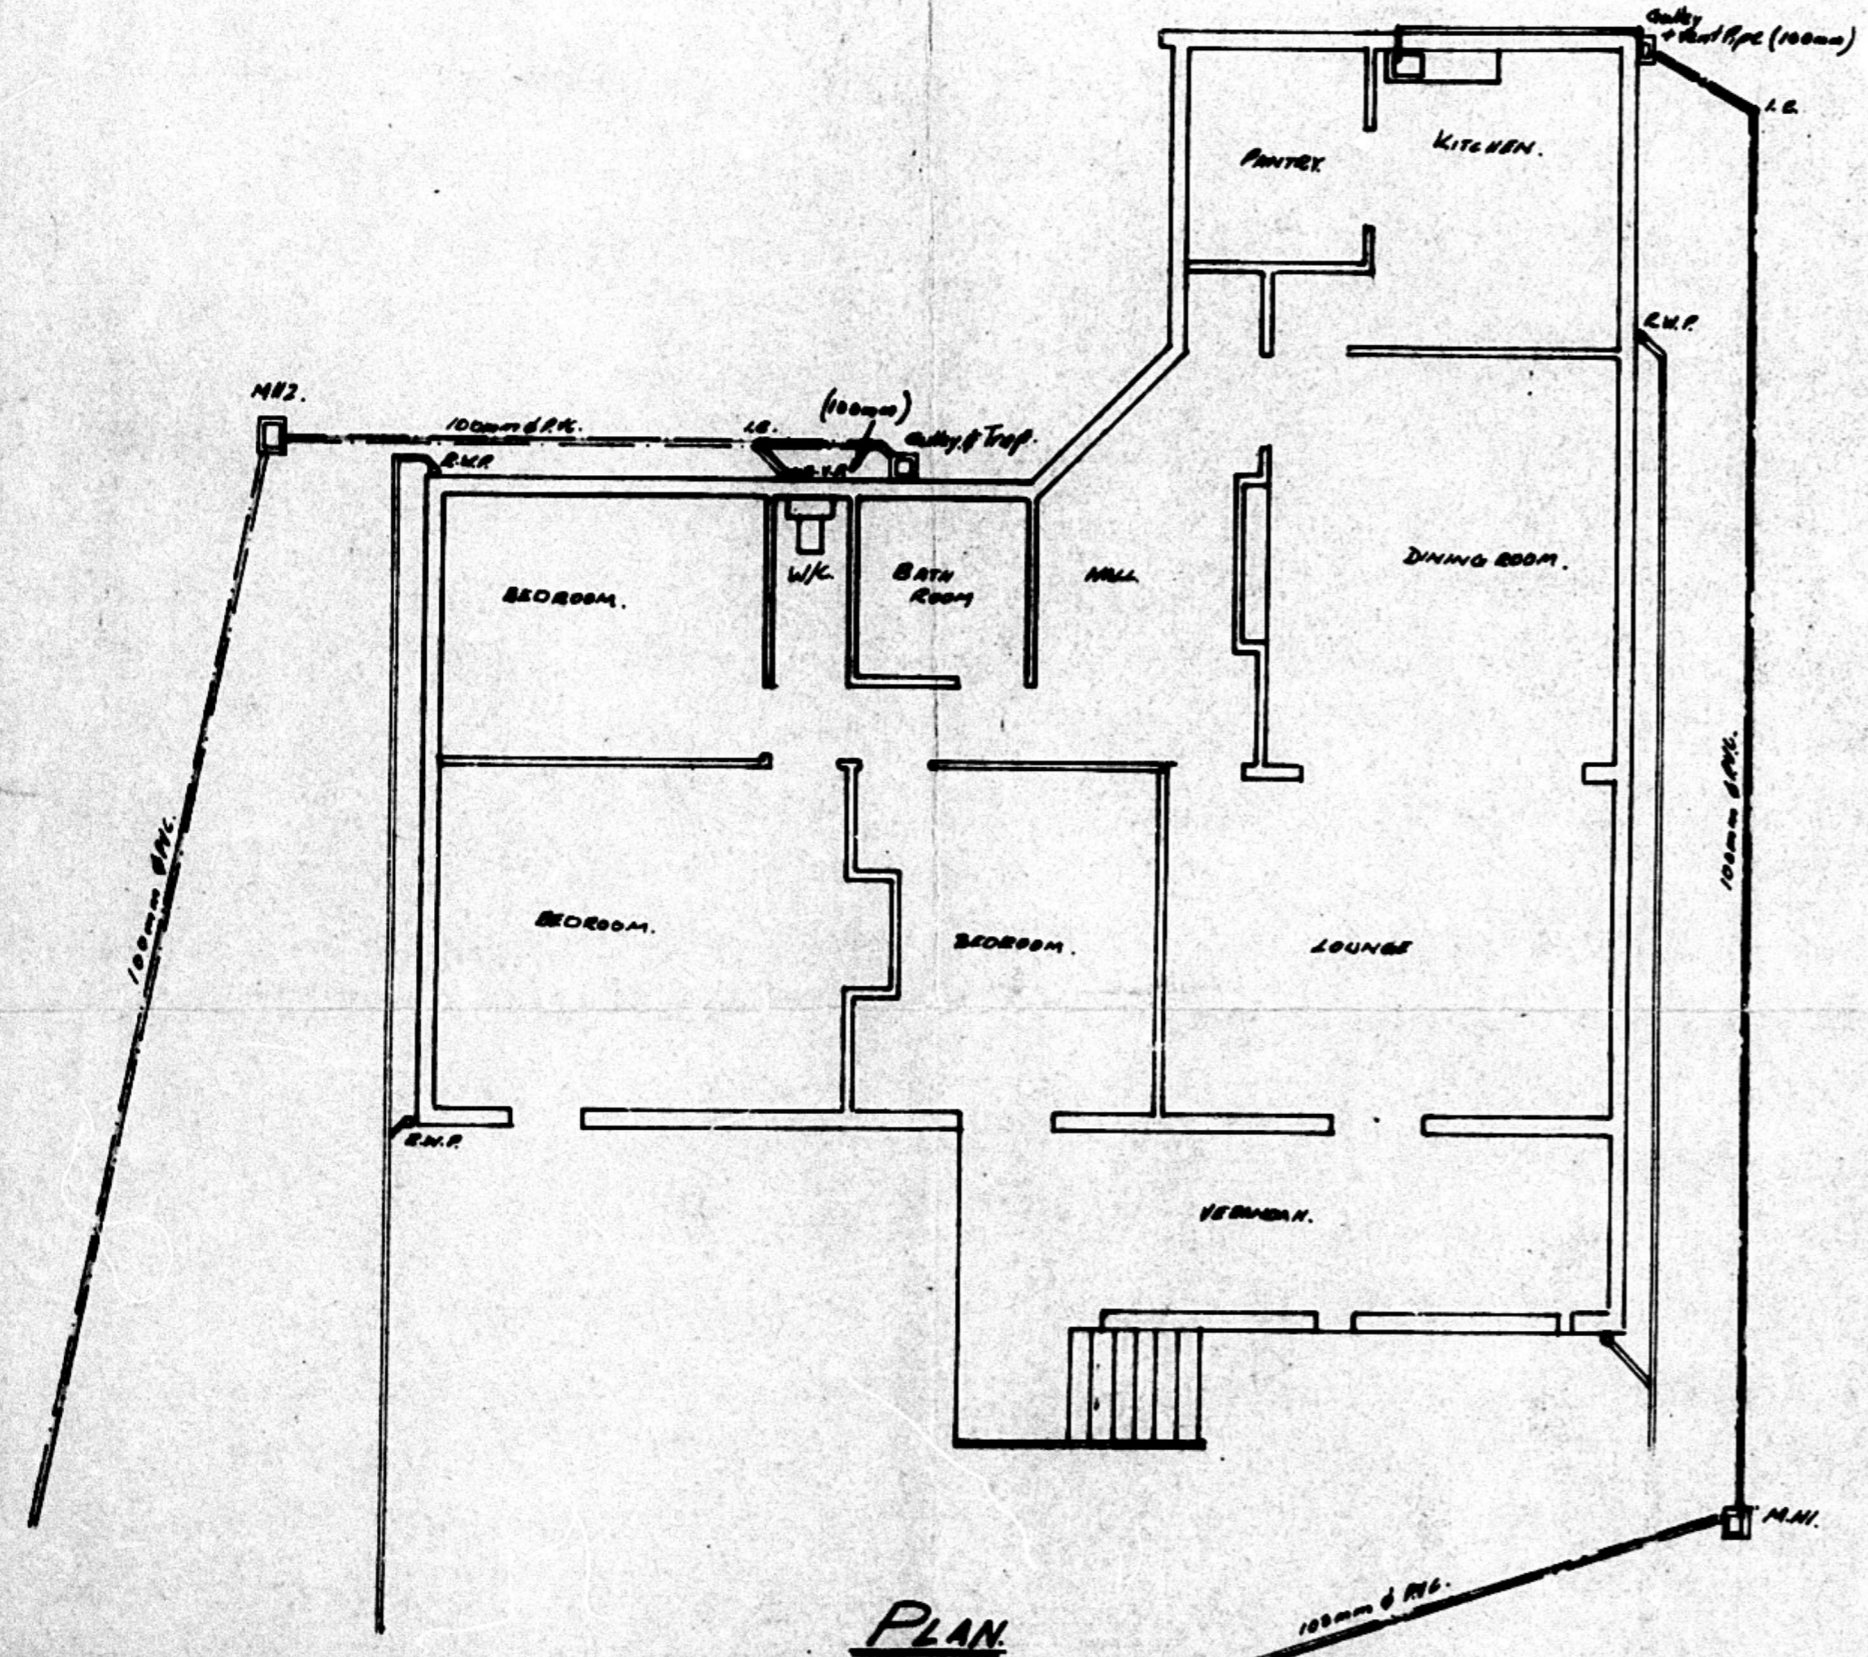

PLAN

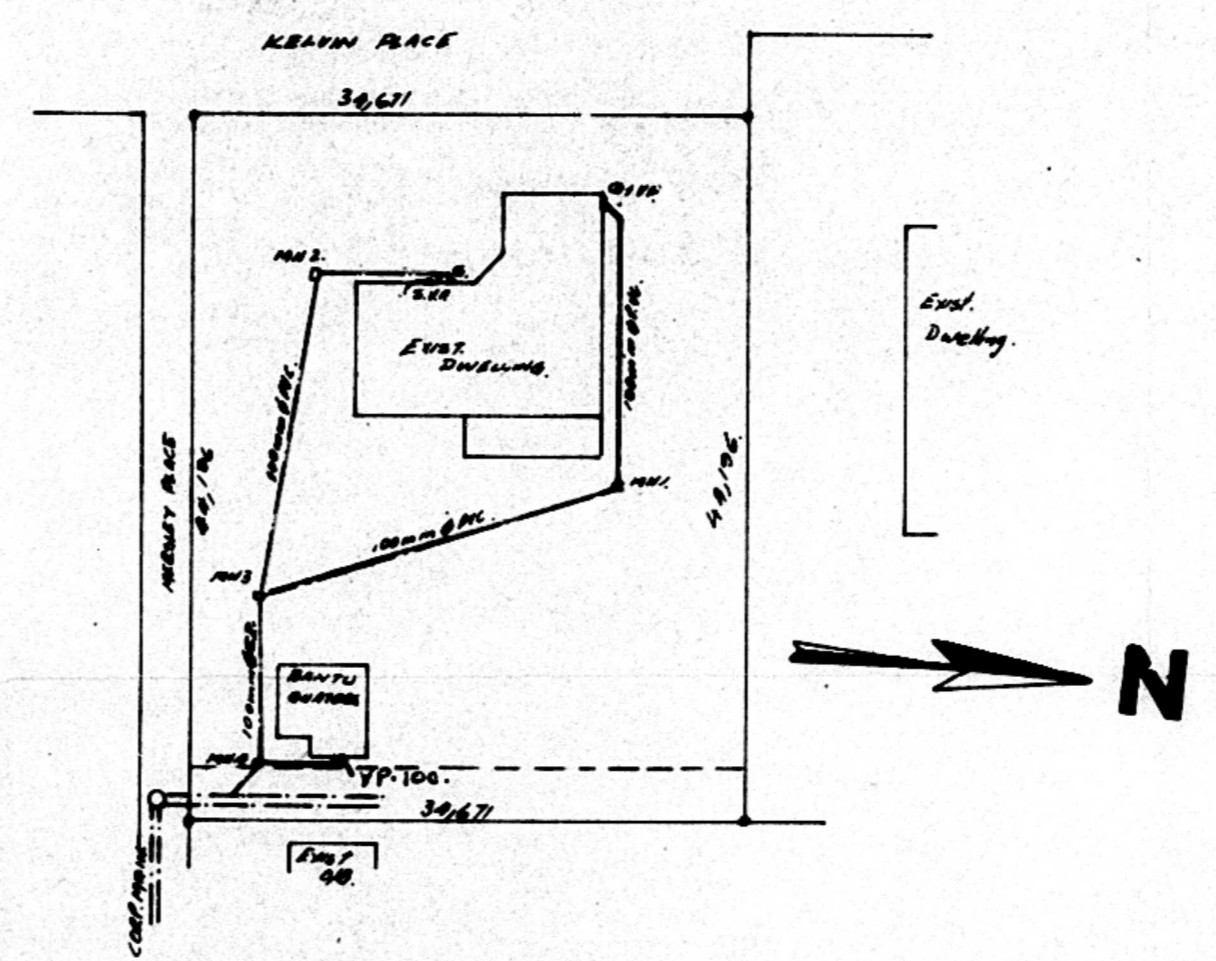

SITE PLAN.

Scale: 1:500.
Title: 60 of Block 2 of V.C.

PLAN SUBSTITUTED 27.12.74
SHEET SUBSTITUTED
SHEET ADDED

SHEET 1/1 COPY 3

CITY OF DURBAN
PLAN No. 439/11/74.
APPROVED
C. G. HANDS DATE - 8 JAN 1975
CITY ENGINEER

All existing wastes, drains, soil & vent pipes to conform to current By-Laws

Contractor to expose the D.C. Sewer at proposed point of connection and ascertain correct invert level. Invert of last M.H. to be set, (allowing a reasonable fall to D.C. Sewer) prior to installing any other drainage work.

34 KELVIN PLACE.
SEWER

ORIGINAL AS BUILT

6/1/77

Scale 1:100 1:200 & 1:500
Date: 8-11-74

PROPOSED SEWER LAYOUT AT 34 KELVIN PLACE DURBAN NORTH
FOR NORMAN F.D LOUGH ESQ.

OWNER'S SIGNATURE: [Signature]

[Signature]