




WEST ELEVATION 1:100

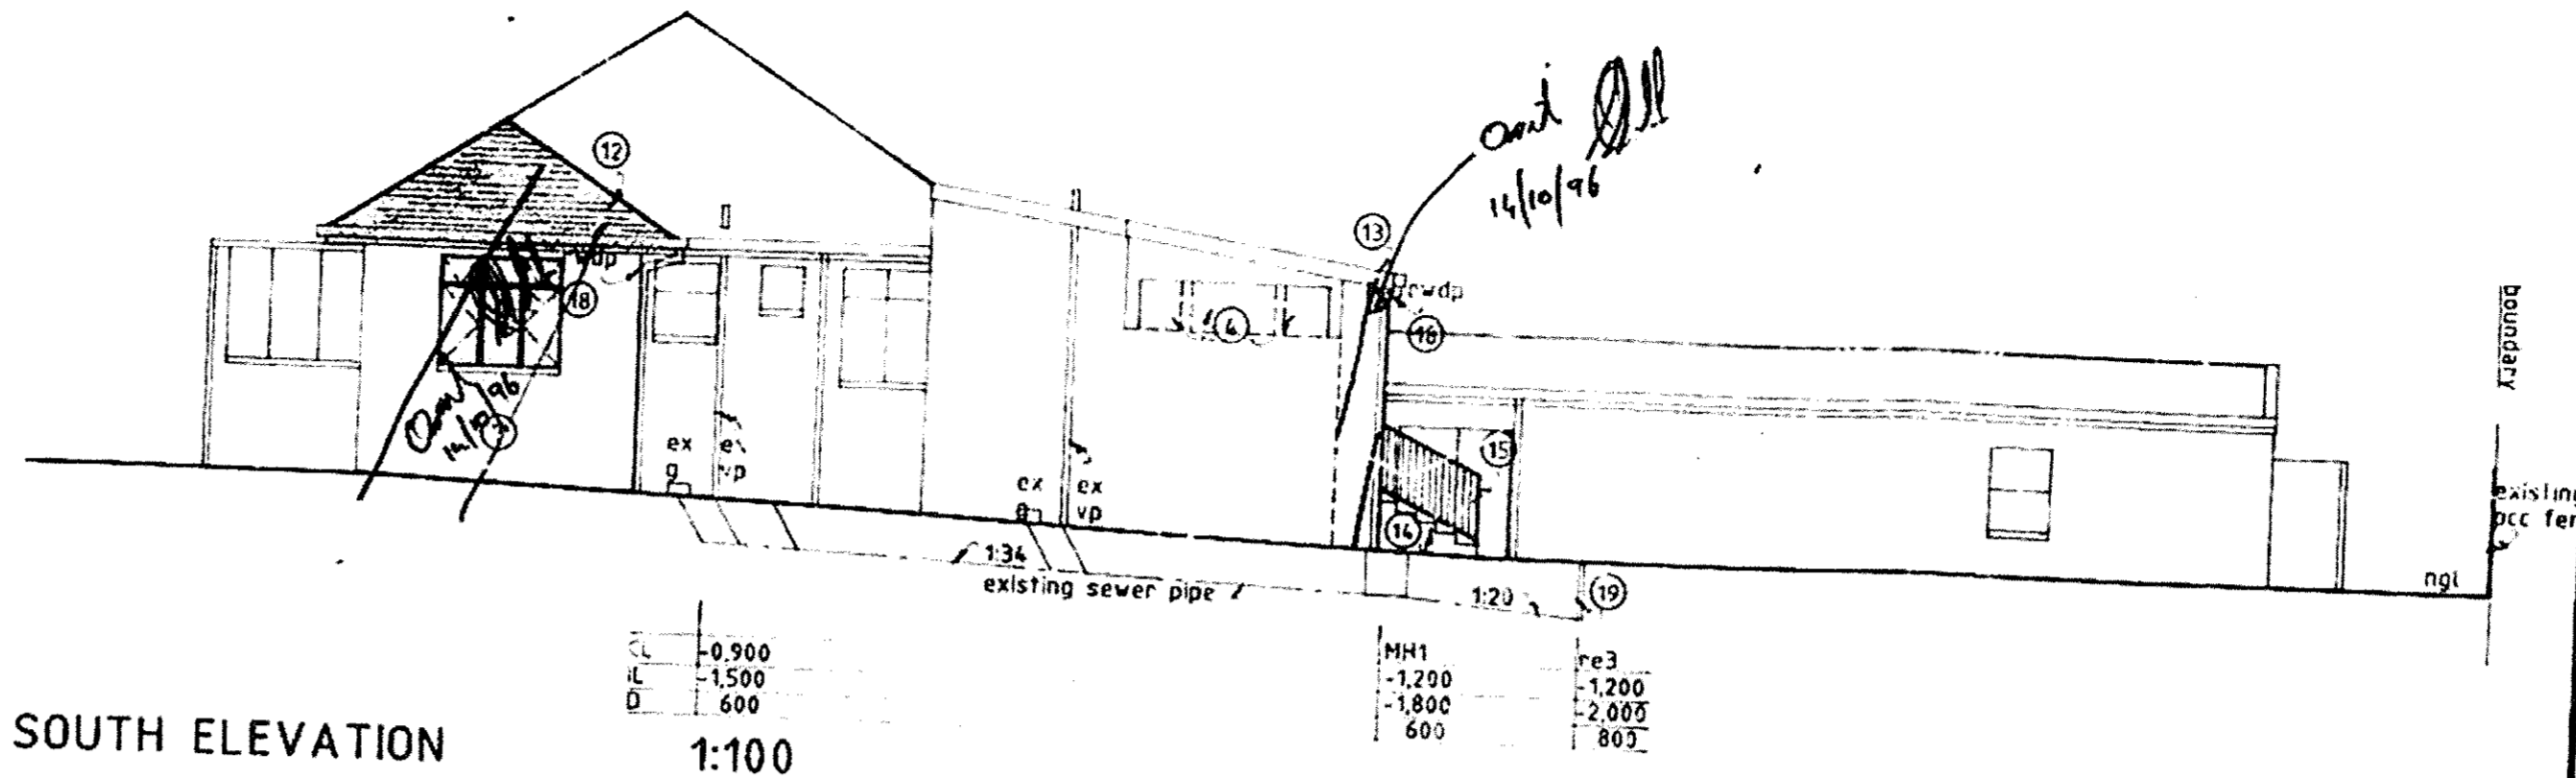


SOUTH ELEVATION 1:100

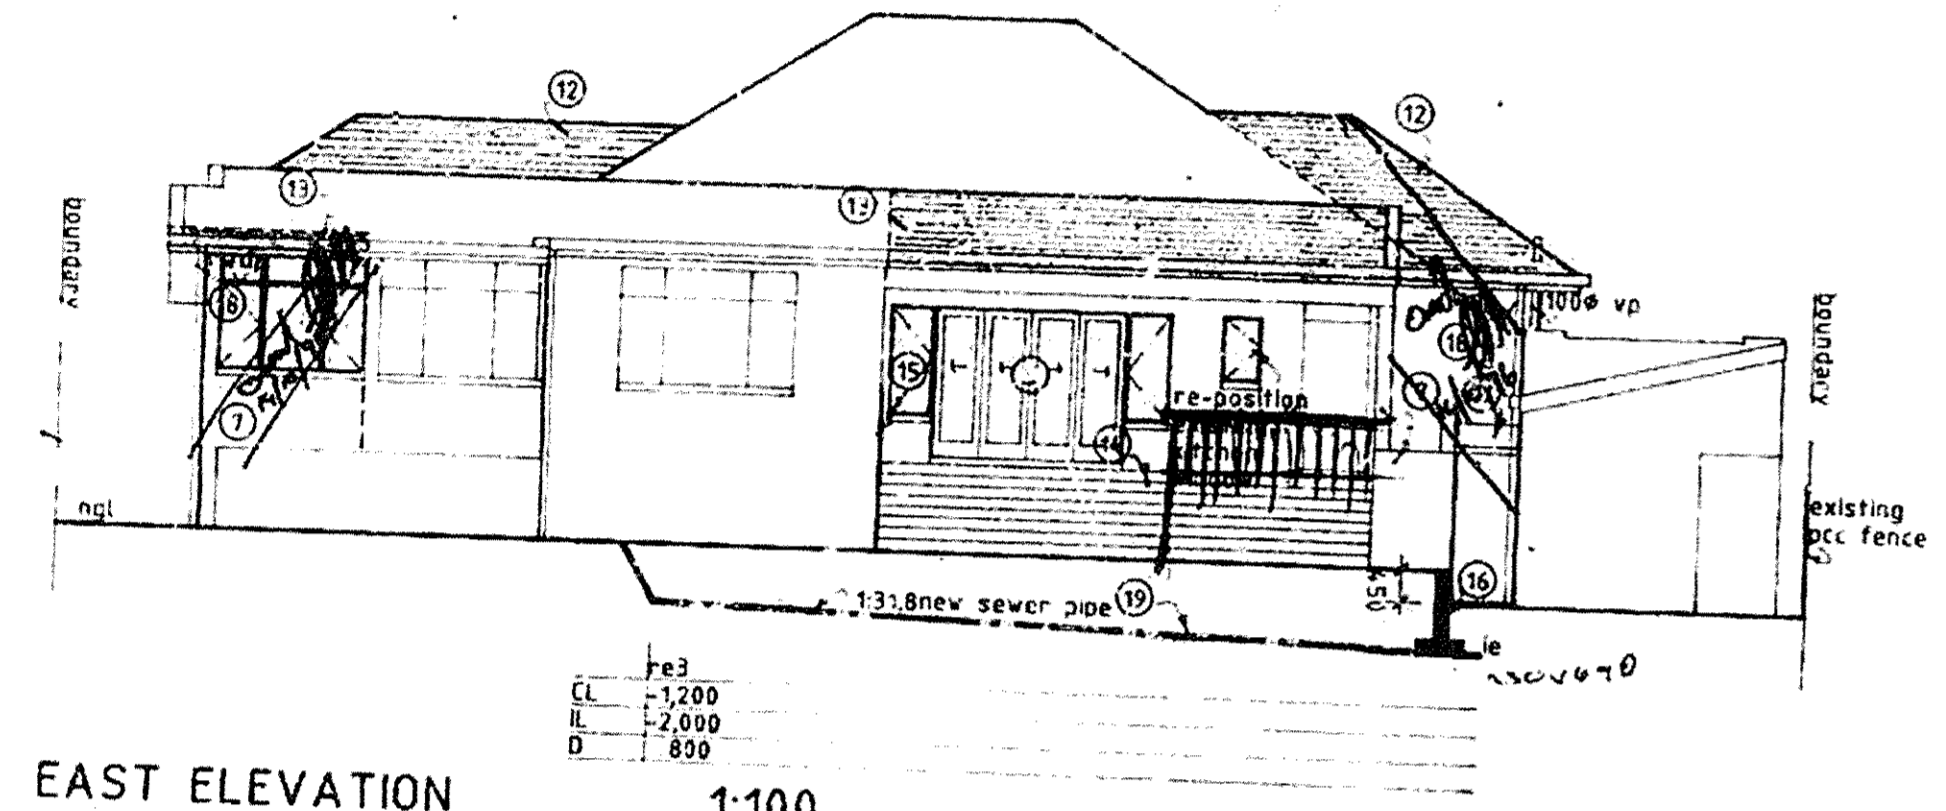


EAST ELEVATION 1:100

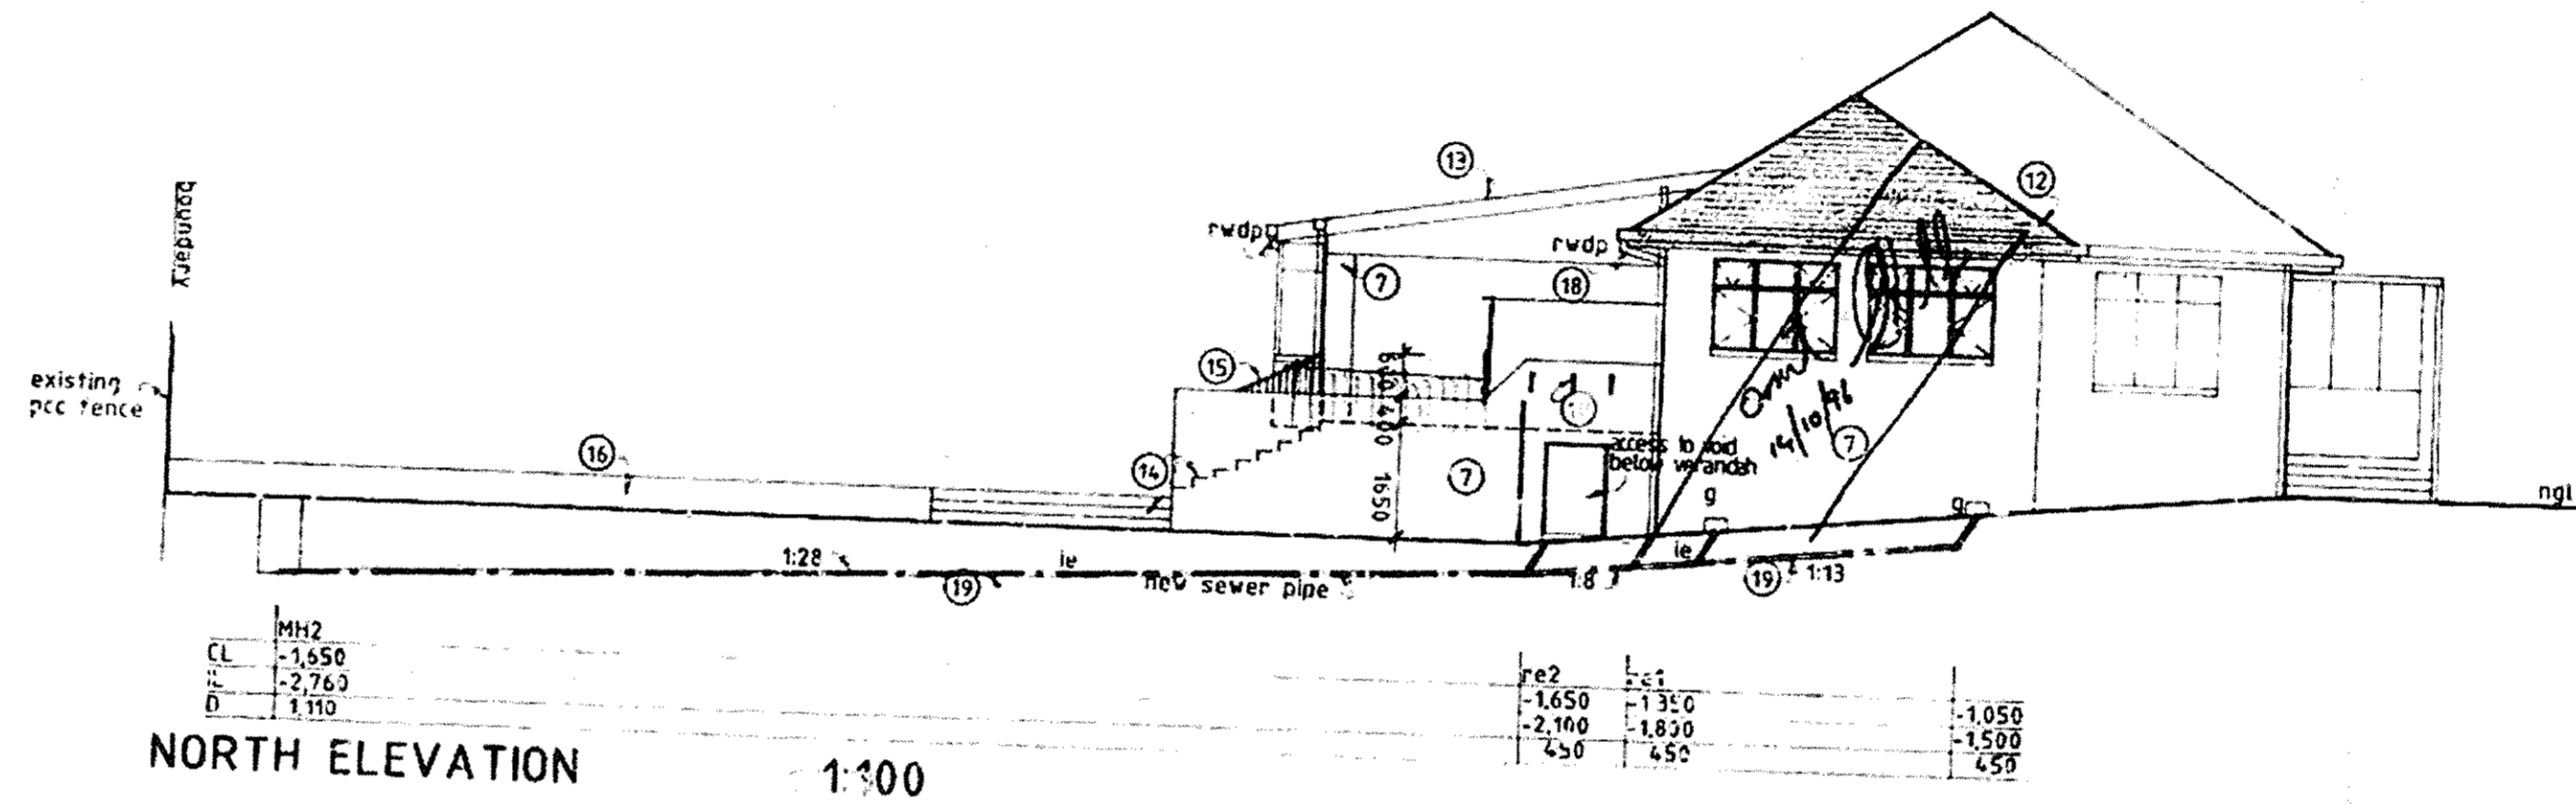


NORTH ELEVATION 1:100

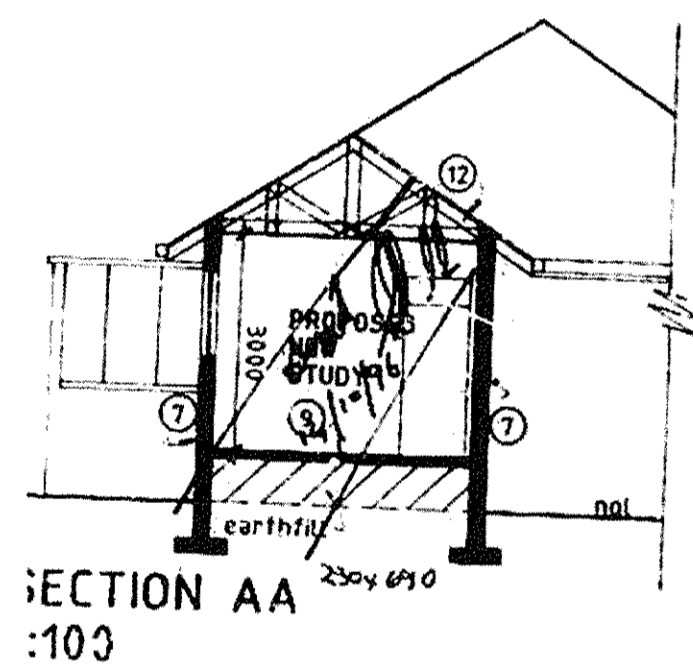


SECTION AA 1:100

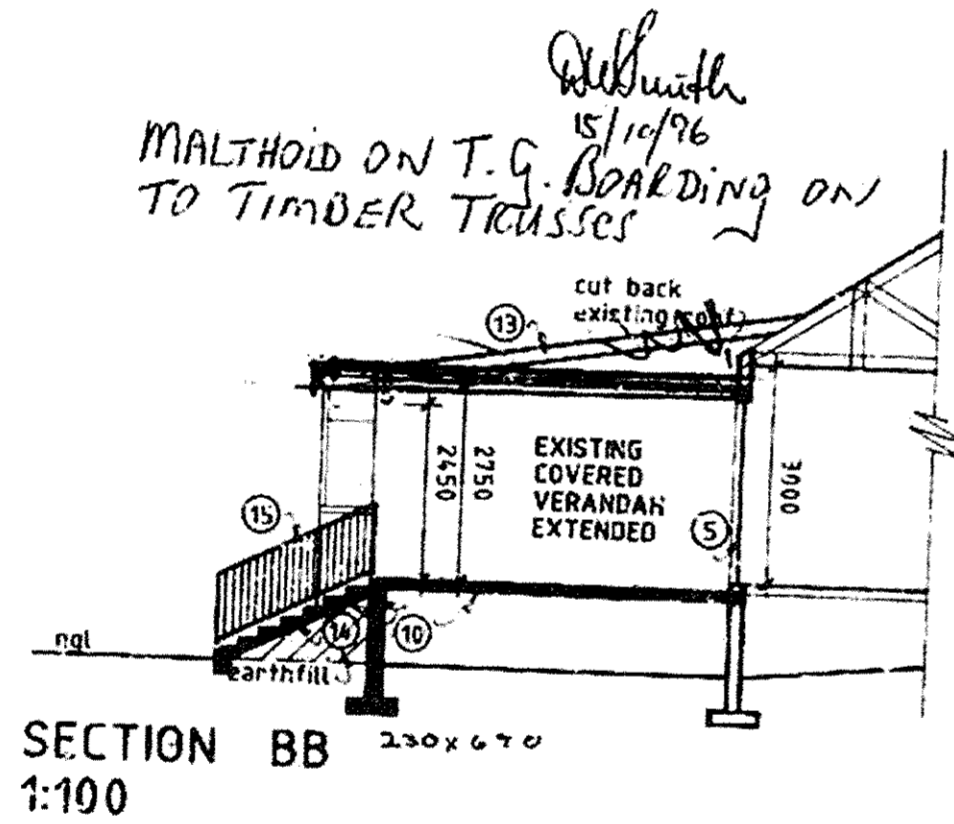

SECTION BB 1:100

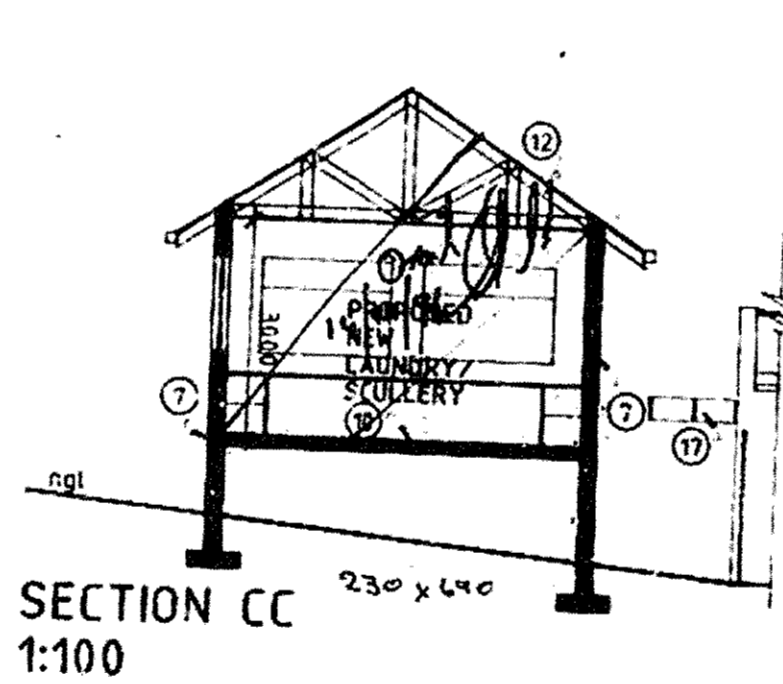

SECTION CC 1:100

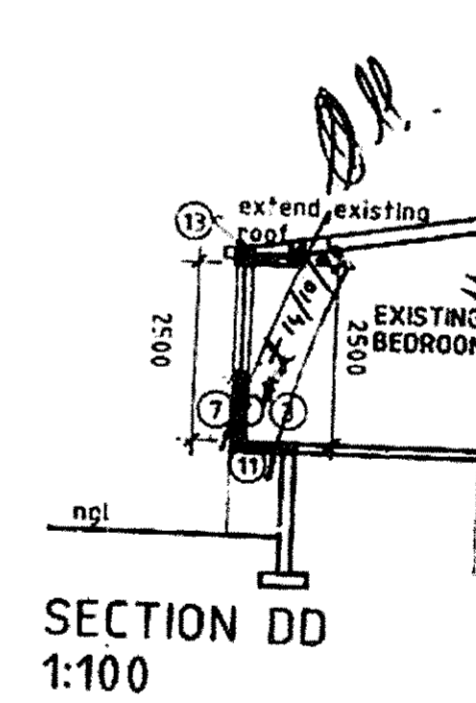

SECTION DD 1:100

SHEET 2/2 COPY 3
CITY OF DURBAN
 PLAN NUMBER
 0553-09-94-2
 APPROVED: R. A. MOORE
 EXECUTIVE DIRECTOR, PHYSICAL
 ENVIRONMENT SERVICE UNIT
 1004 11.17.96

AS BUILT
Stewart 9/6/98

ELECTRICITY SERVICES
 Any person installing or having installed
 in accordance with the requirements
 of the Electricity Act, 1962, any
 electrical installation, shall
 1) The installation shall be in accordance with the requirements of the Electricity Act, 1962.
 2) The installation shall be in accordance with the requirements of the Electricity Act, 1962.

DEVELOPMENT CONTROL DEPT.
 TOWN PLANNING AUTHORITY
GRANTED
 Signature: *R. A. Moore*
 Checked: *R. A. Moore*

CITY OF DURBAN
 WATER SUPPLY DEPARTMENT
 APPROVED
 APPROVAL OF WATER SUPPLY SYSTEM
 FOR OCCUPATION
 1004 11.17.96
M. J. ...

Vol. 8/ 2013 1007/000

Project Title:
**PROPOSED ALTERATIONS
 & ADDITIONS TO
 EXISTING DWELLING
 FOR
 MR & MRS CS SMITH
 AT
 6 REGENT PLACE
 DURBAN NORTH**

Drawing Title:
ELEVATIONS & SECTIONS

Jean Stewart Architect
 P O Box 1069, Durban, 4000 • Tel 031-289819 • Fax 031-2071268

Date: SEPT 1996 Drawn: JAS/CVL Drawing Number: 9408/W02