

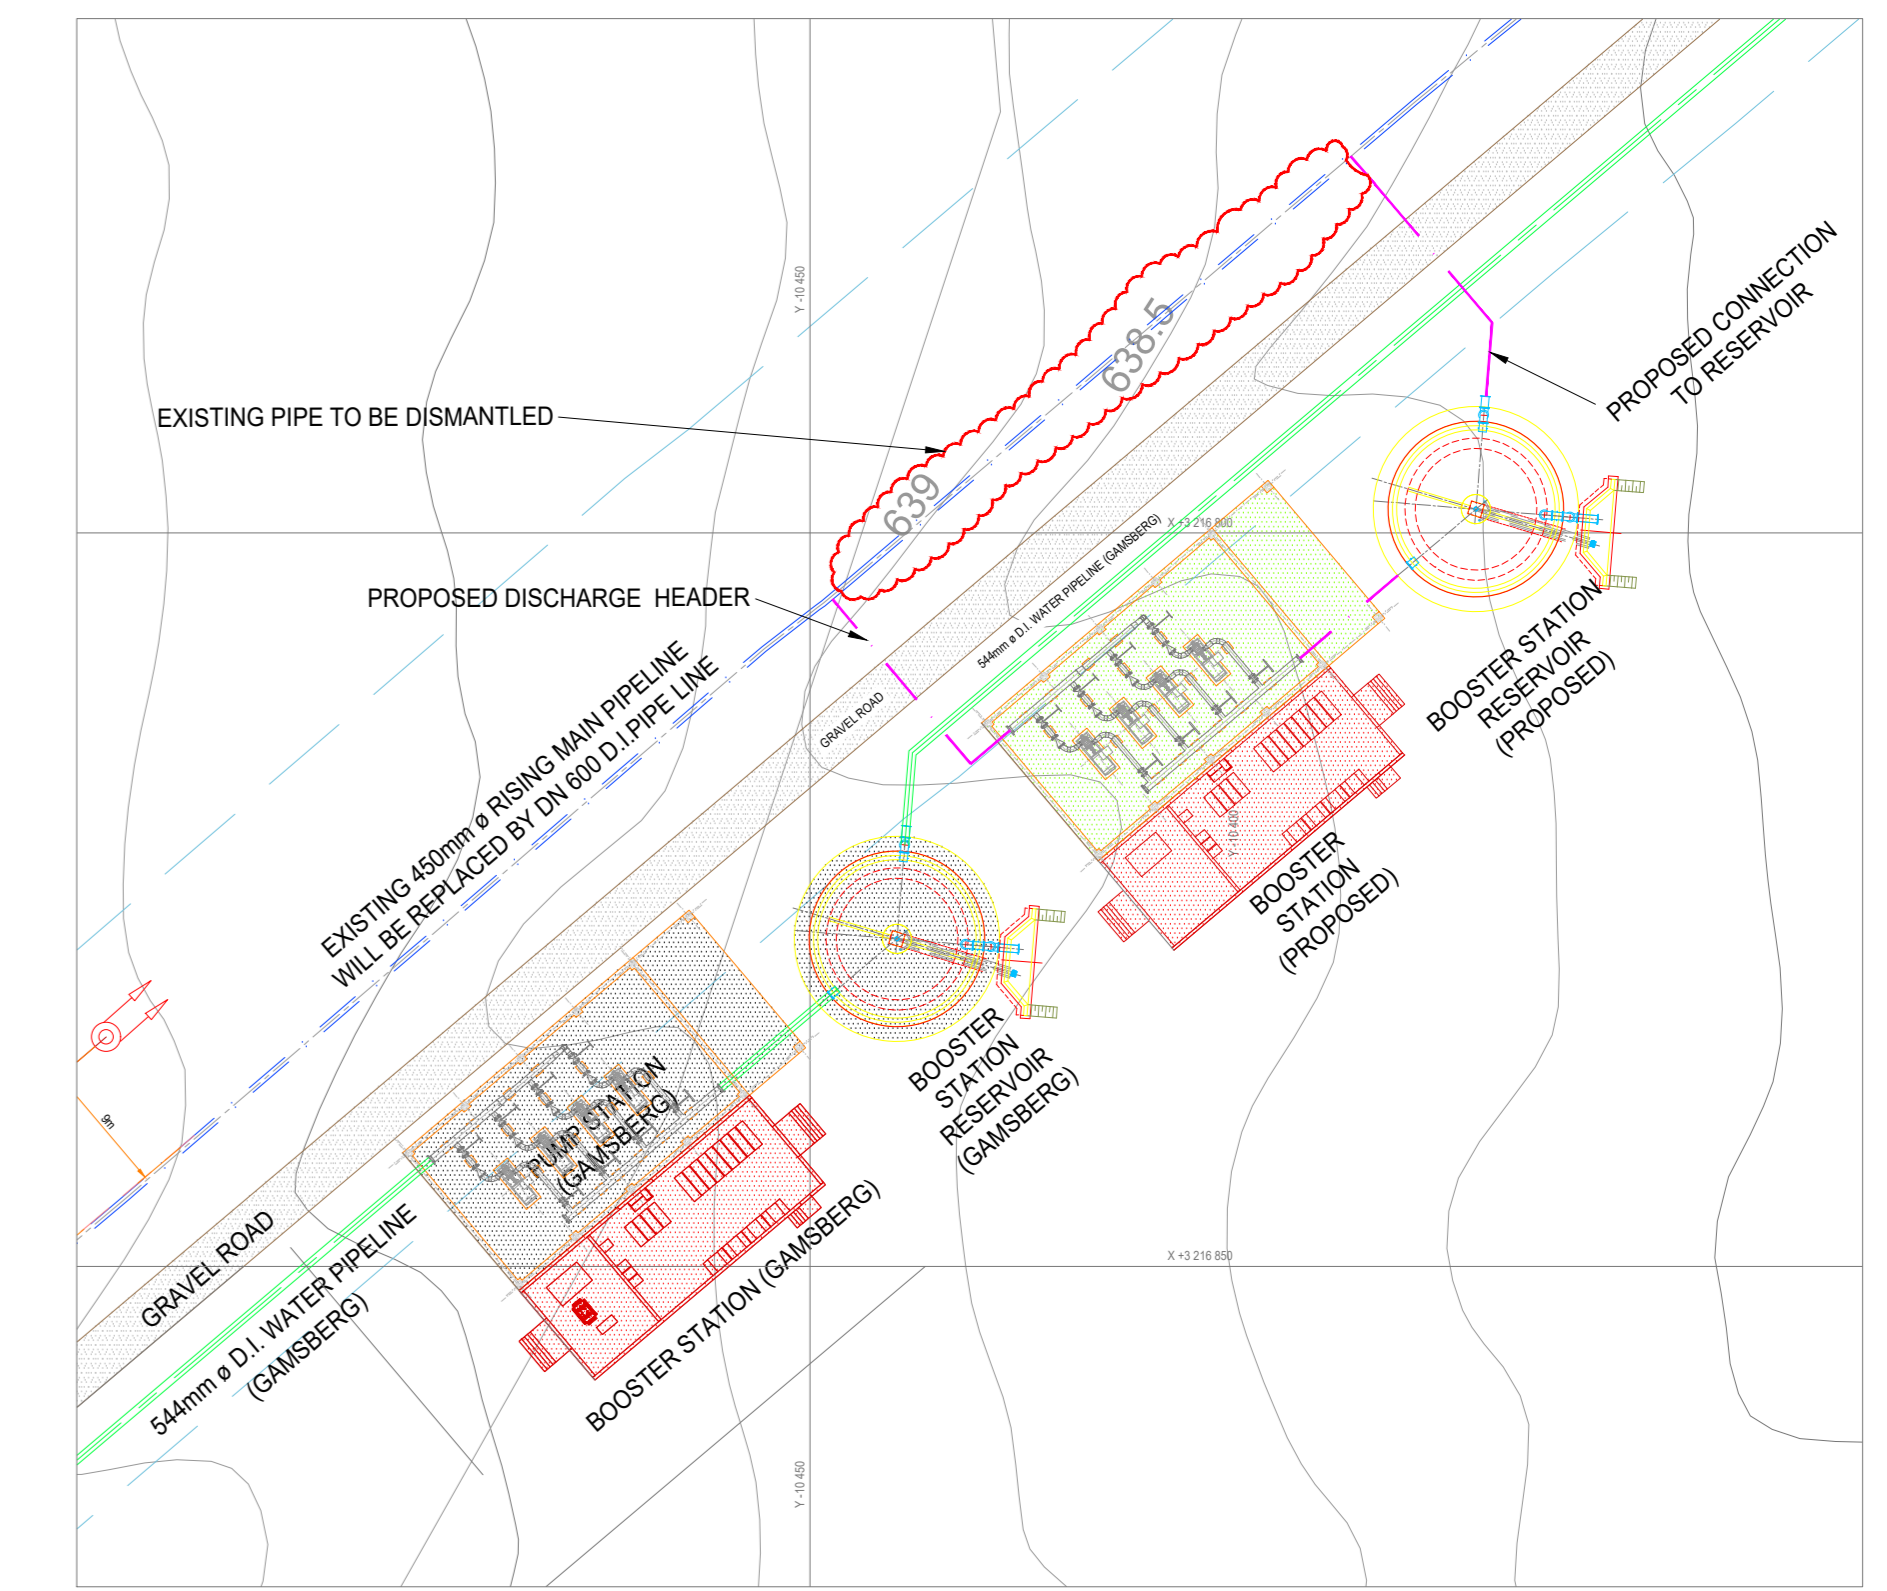


APPENDIX C: FACILITY ILLUSTRATION

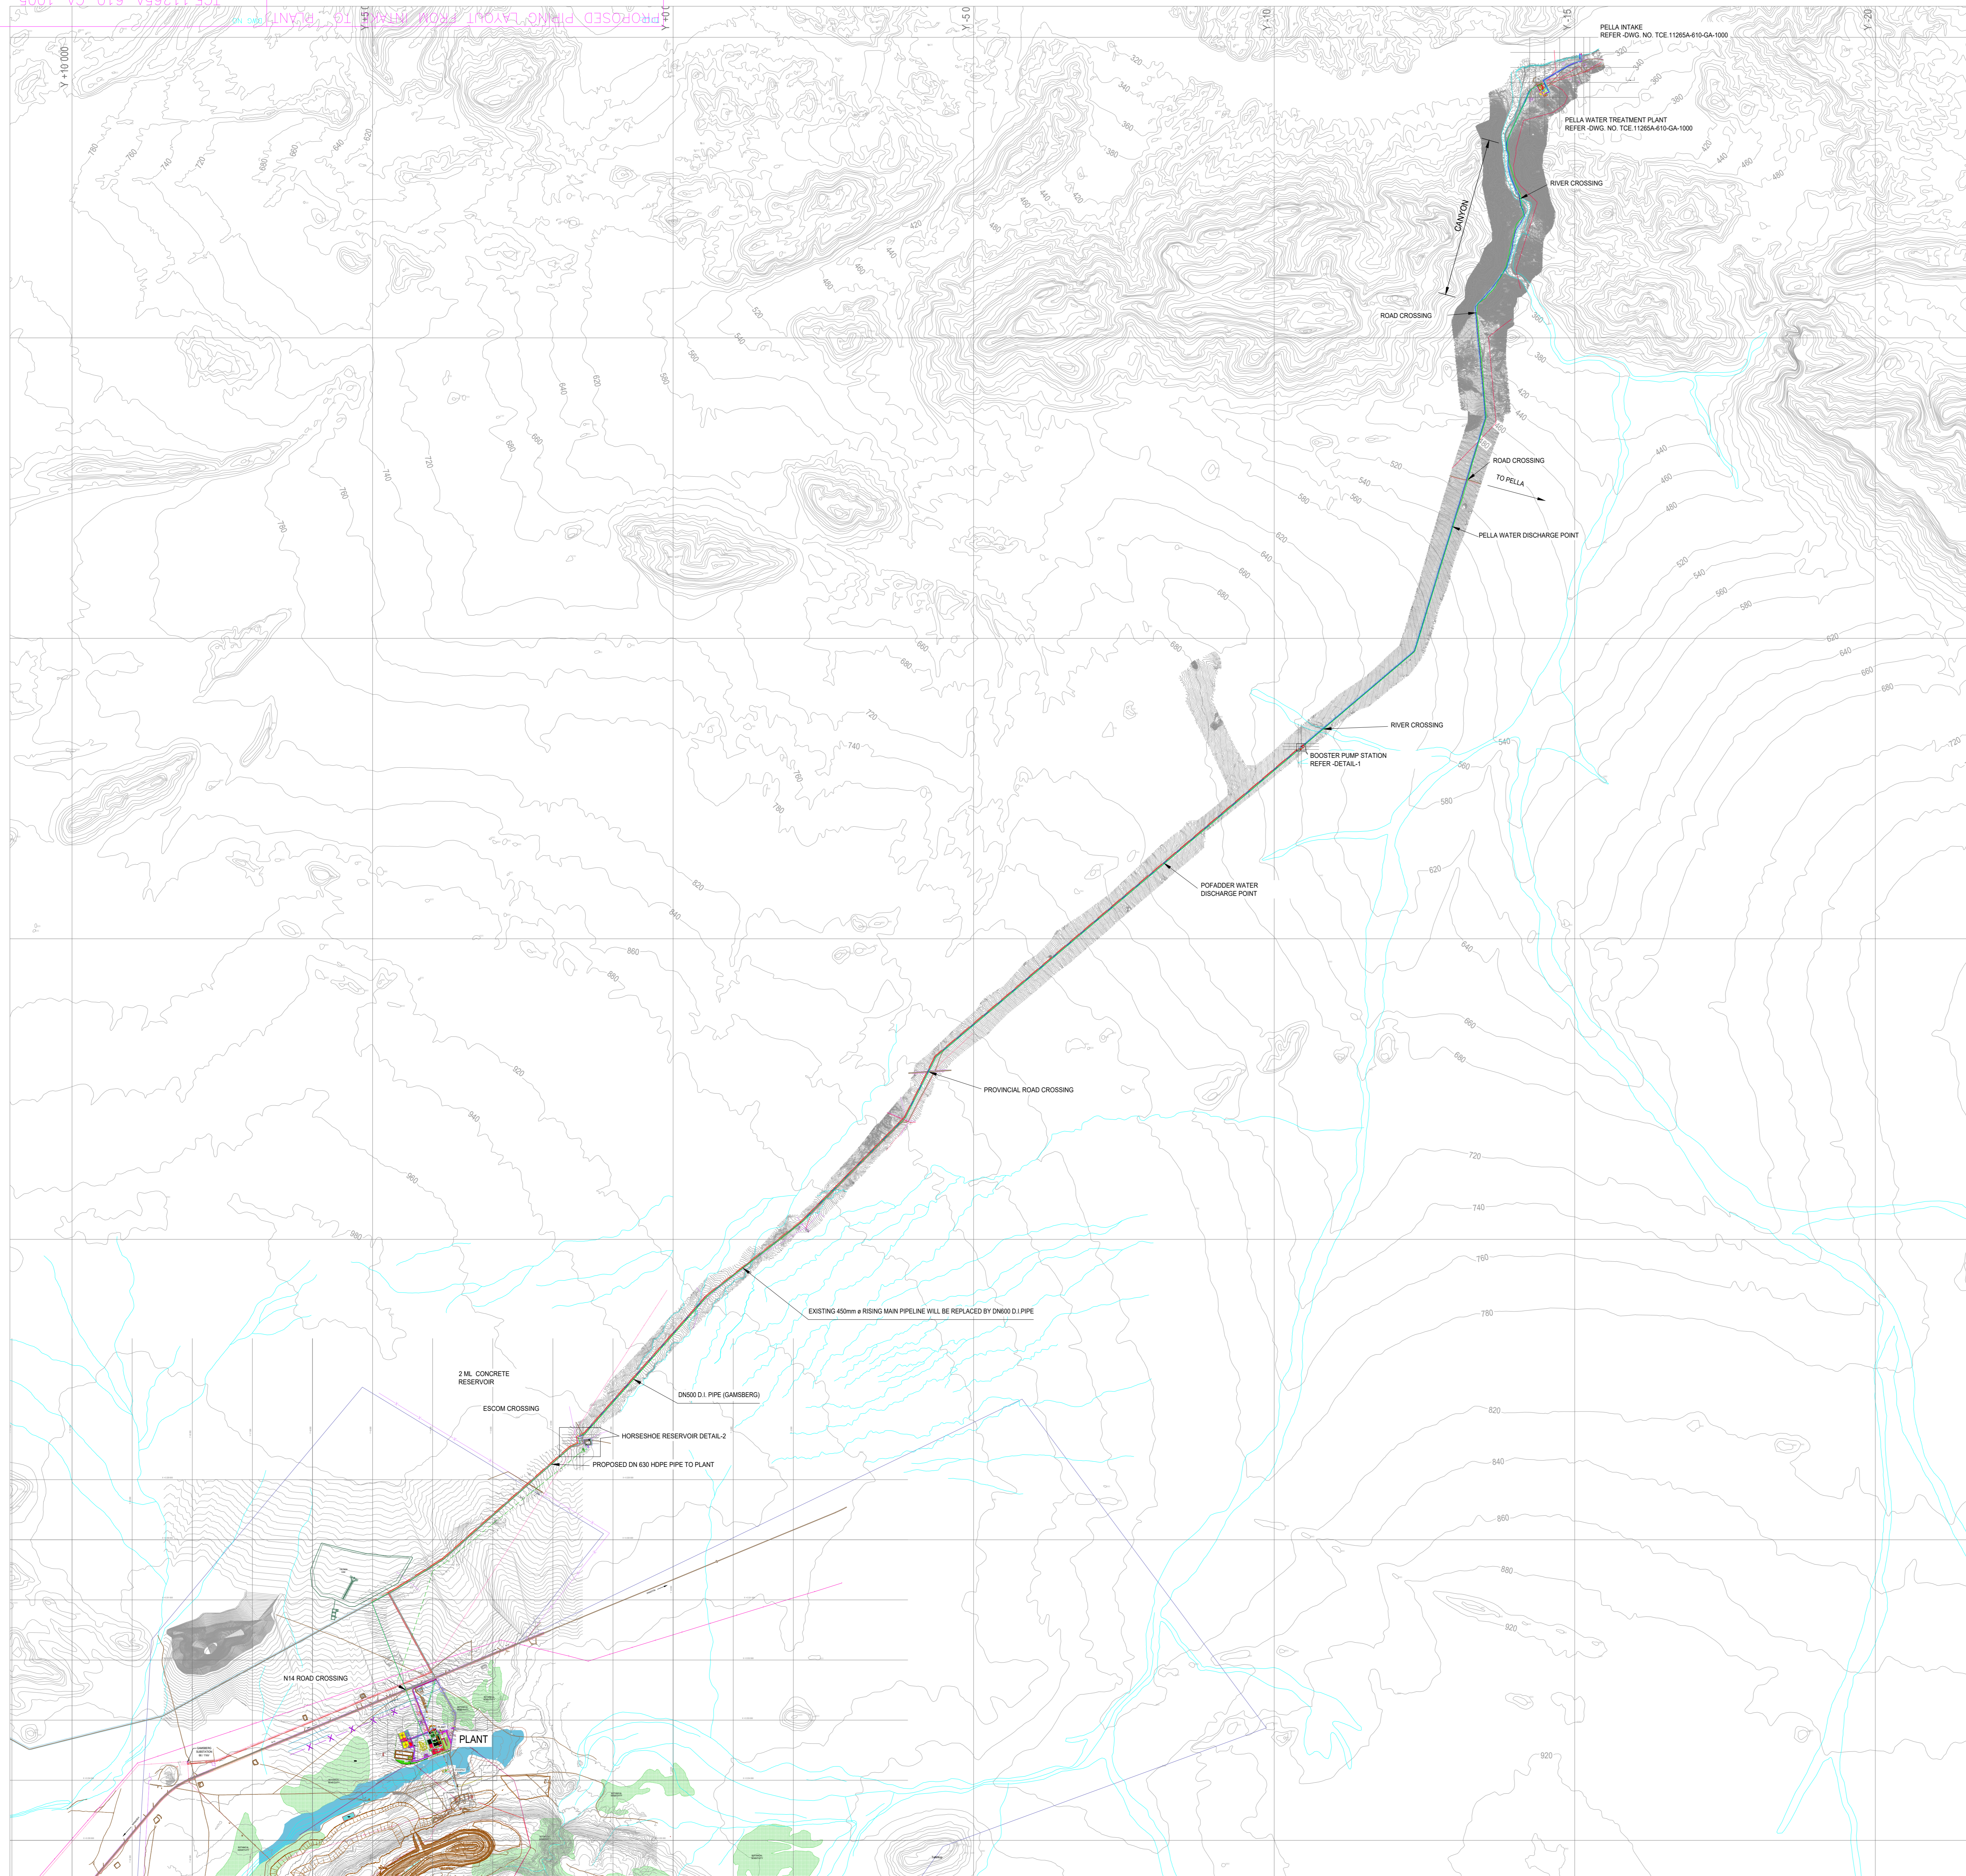

DETAIL-1

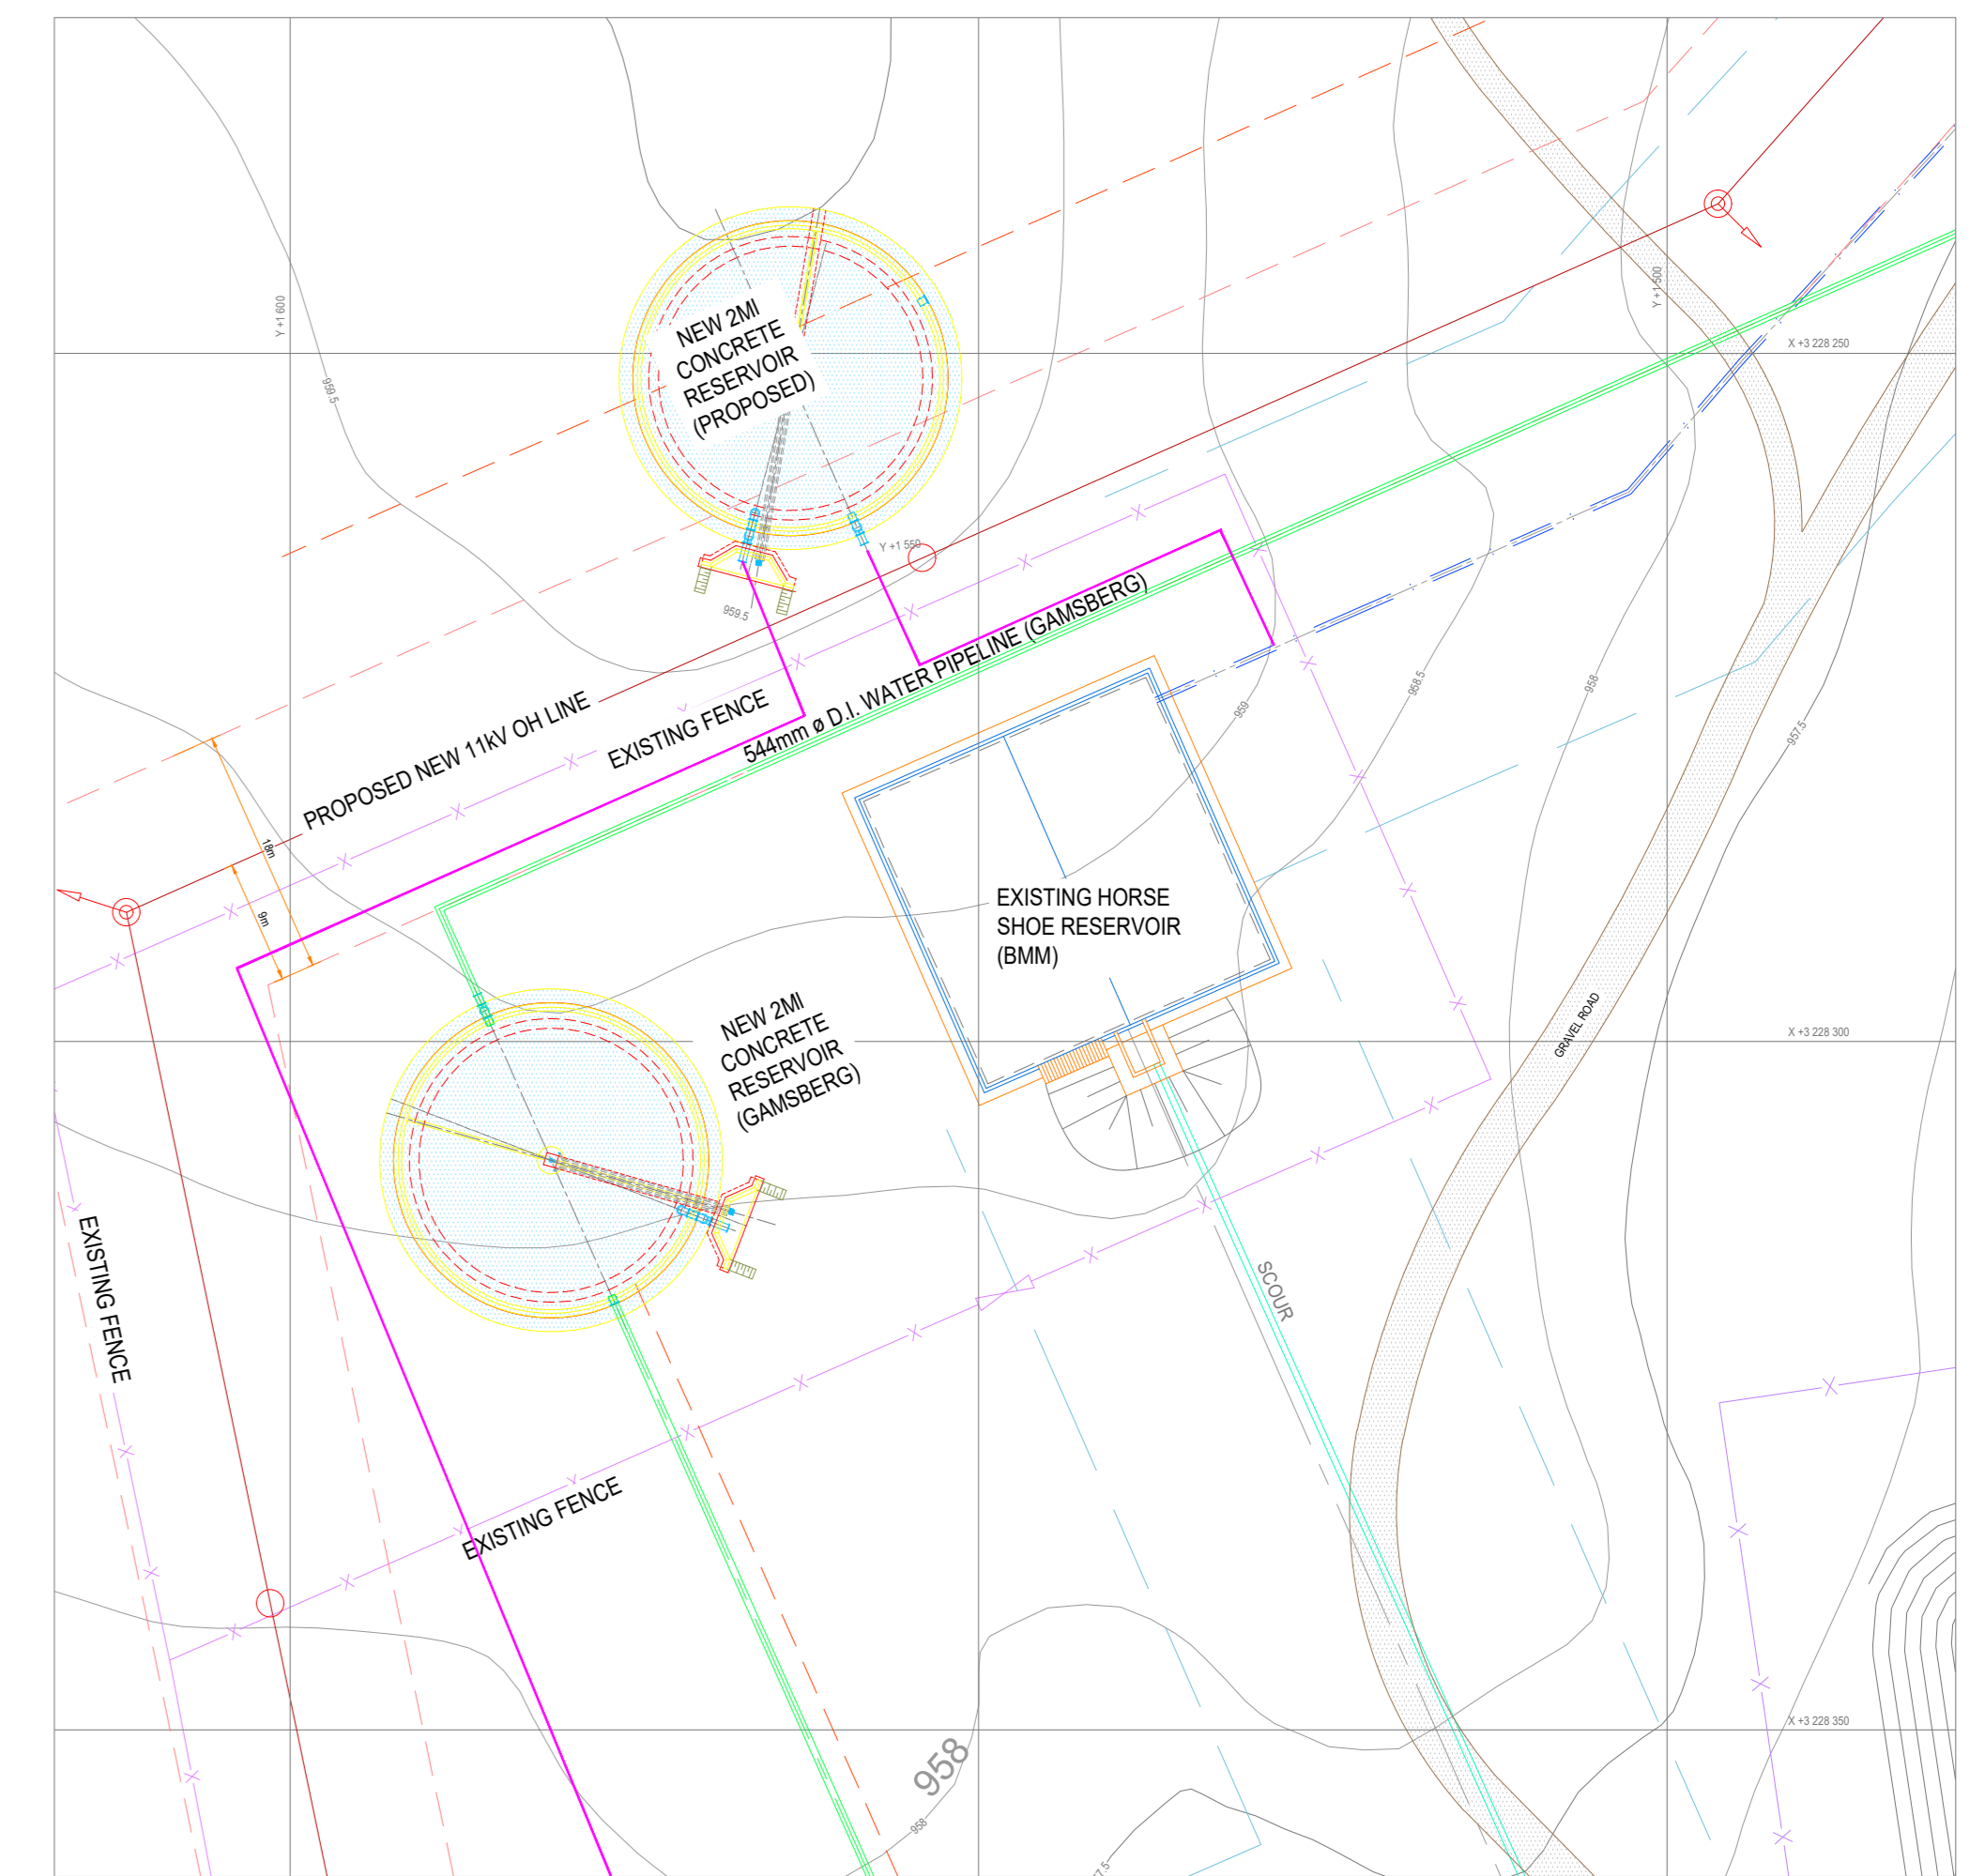

DETAIL-2

DO NOT SCALE

IF PRELIMINARY ISSUES ARE NOT TO BE USED FOR CONSTRUCTION / FABRICATION BUT ARE ISSUED FOR LIMITED PURPOSES ONLY, AS INDICATED IN THE SMALL BLOCK ABOVE THIS BLOCK, CONSTRUCTION / FABRICATION WORK IS PERMITTED ON 'R' (RELEASED) ISSUES ONLY. INFORMATION CONTAINED WITHIN 'HOLD' IS NOT RELEASED FOR CONSTRUCTION / FABRICATION. FIELD MUST GET DESIGN OFFICE TO CLEAR 'HOLD' IN TIME BEFORE PROCEEDING WITH ANY CONSTRUCTION / FABRICATION WORK RELATED TO 'HOLD'.

Proprietary rights of the information contained herein belong to TCE. This information is intended to be used for the mentioned purpose only. In case of misuse of information and any claim arising therefrom, TCE and its subsidiaries will not be liable for the same.

ISSUE	DRN	DSN	CHD	CV	EL	IC	ME	PD/WK	PD	08-08-2019
								PL/PM	APPD	DATE

BLACK MOUNTAIN MINING (Pty) LTD.
GAMBERG 300KTPA ZINC SMELTER REFINERY PROJECT

PROPOSED PIPING LAYOUT FROM INTAKE TO PLANT

TATA CONSULTING ENGINEERS LIMITED
MUMBAI

SCALE: _____ DWG NO: ICE.11265A-610-GA-1005 ISSUE: PO
DC & DISC: _____

