

PROPOSED SEWER DRAINS FOR MR. SWANEPOEL
 ON SUB 2 OF C OF X OF BELLAIR NO 823
 7 WATT ROAD



RATE NO 333940 54

SHEET 111 COPY 3
 CITY OF DURBAN
 PLAN NO. 30/8/82
 APPROVED
 Date: 27 AUG 1982
 D. C. MACLEOD
 City Engineer


ORIGINAL
 AS BUILT
 1/4/82

Contractor to ensure the D.C. drain at proposed point of connection and ascertain correct invert level. Invert of L.I.M.H. to be set, allowing a reasonable fall to D.C. drain prior to installing any other drainage work.

All existing wastes, drains, soil & vent pipes to conform to current By-Laws.

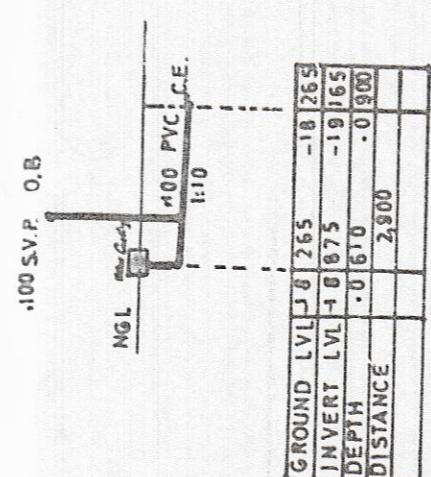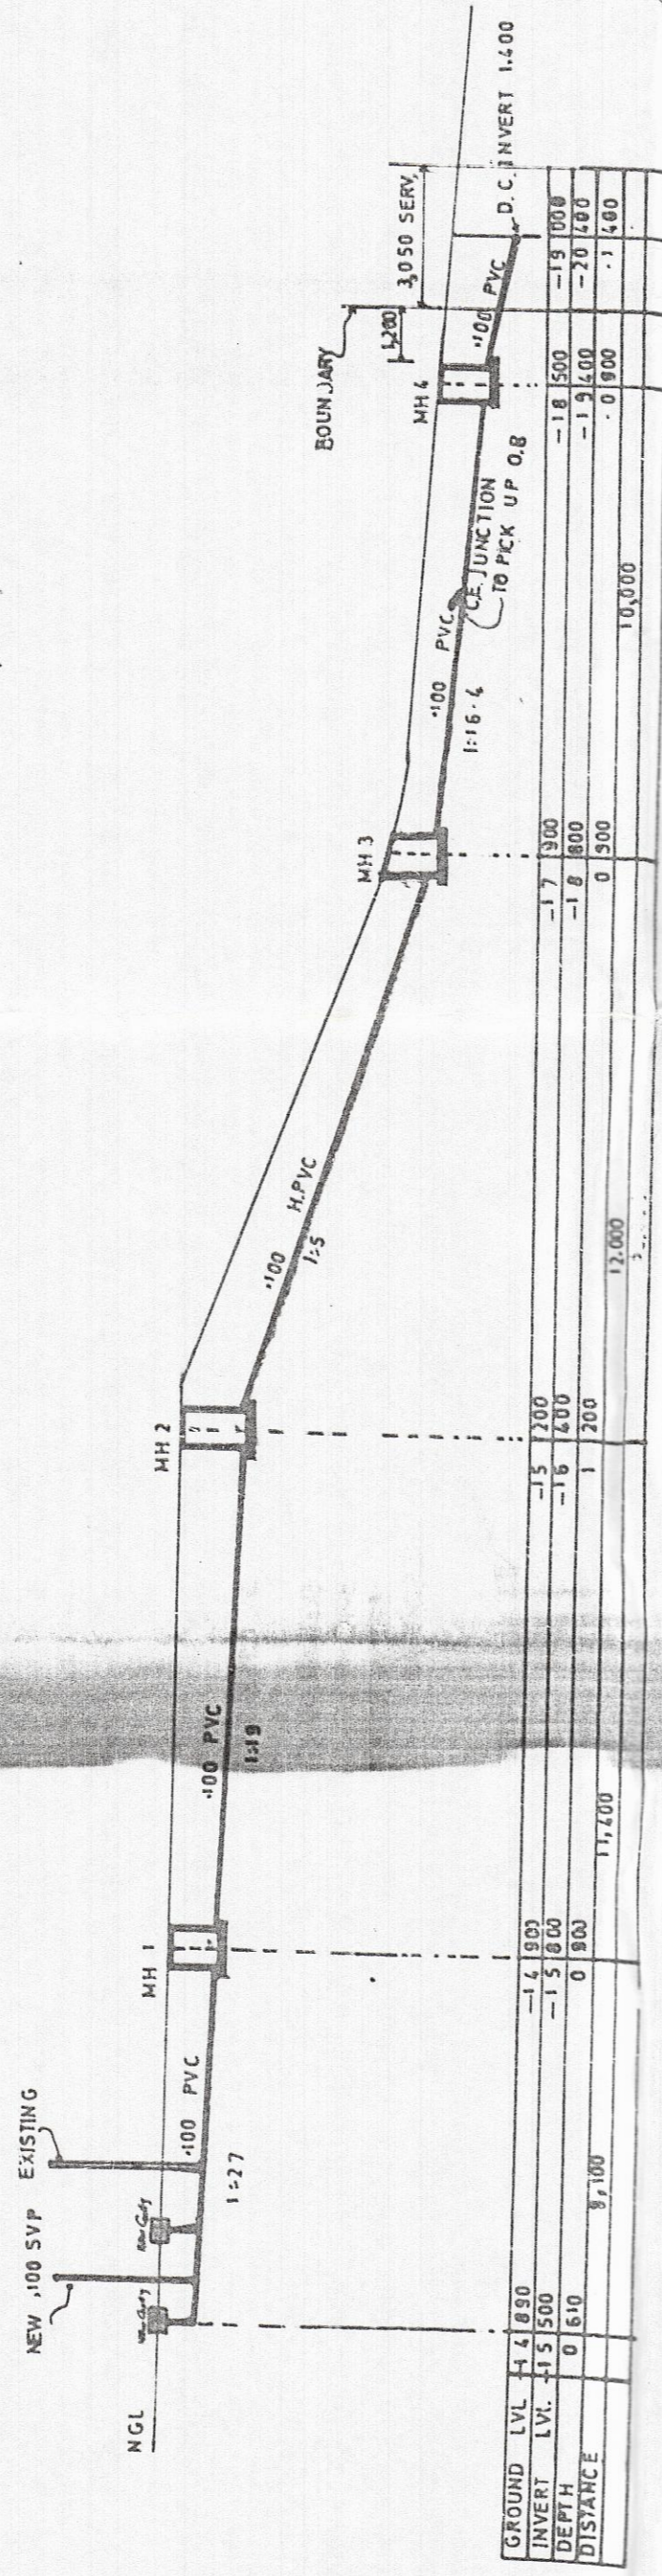

DRAINAGE SECTION
 SCALE 1:100

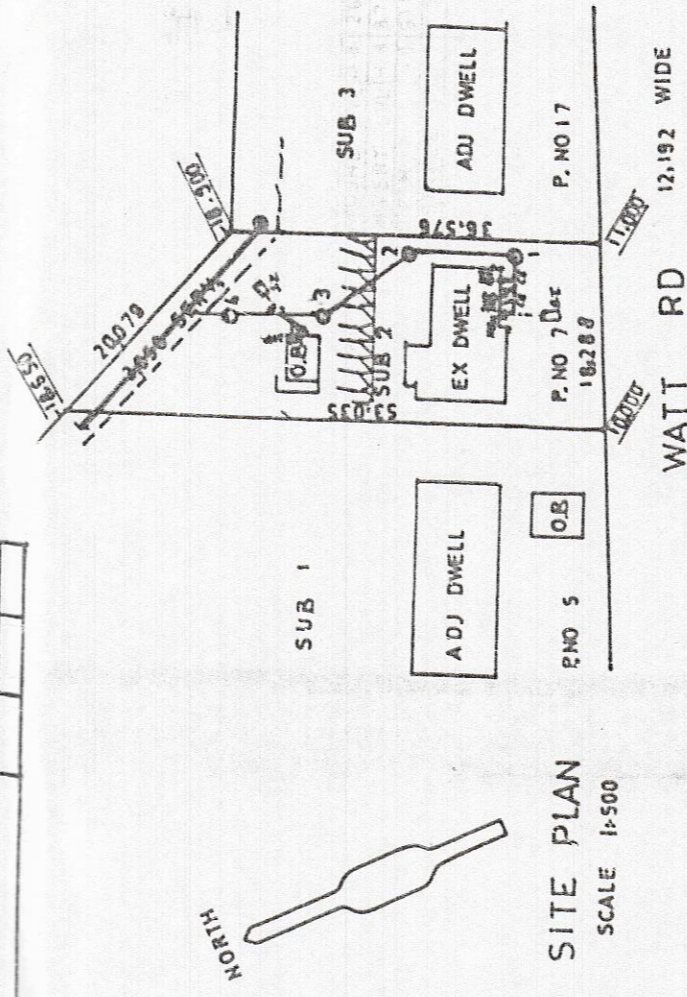

SITE PLAN
 SCALE 1:500

EX SEPTIC TANKS TO BE DE SLUGED AND BACKFILLED

DRAWN BY
 Y. Richter
 14/8/82

