


LEGEND	
	EXISTING BUILDINGS, TANKS
	EXISTING TELEPHONE LINES
	EXISTING POWER LINES
	EXISTING WATER
	EXISTING SEWER
	PROPOSED SEWER
	PROPOSED WATER & VALVES
	300mm RAW WATER LINE
	PROPOSED PIPE CONNECTIONS
	EXISTING TELEGRAPH POLES
	TELEGRAPH POLES TO BE REMOVED
	TELEGRAPH CABLE DUCTS
	DYNAMIC CONE PENETROMETER TEST PITS
	TEST PITS

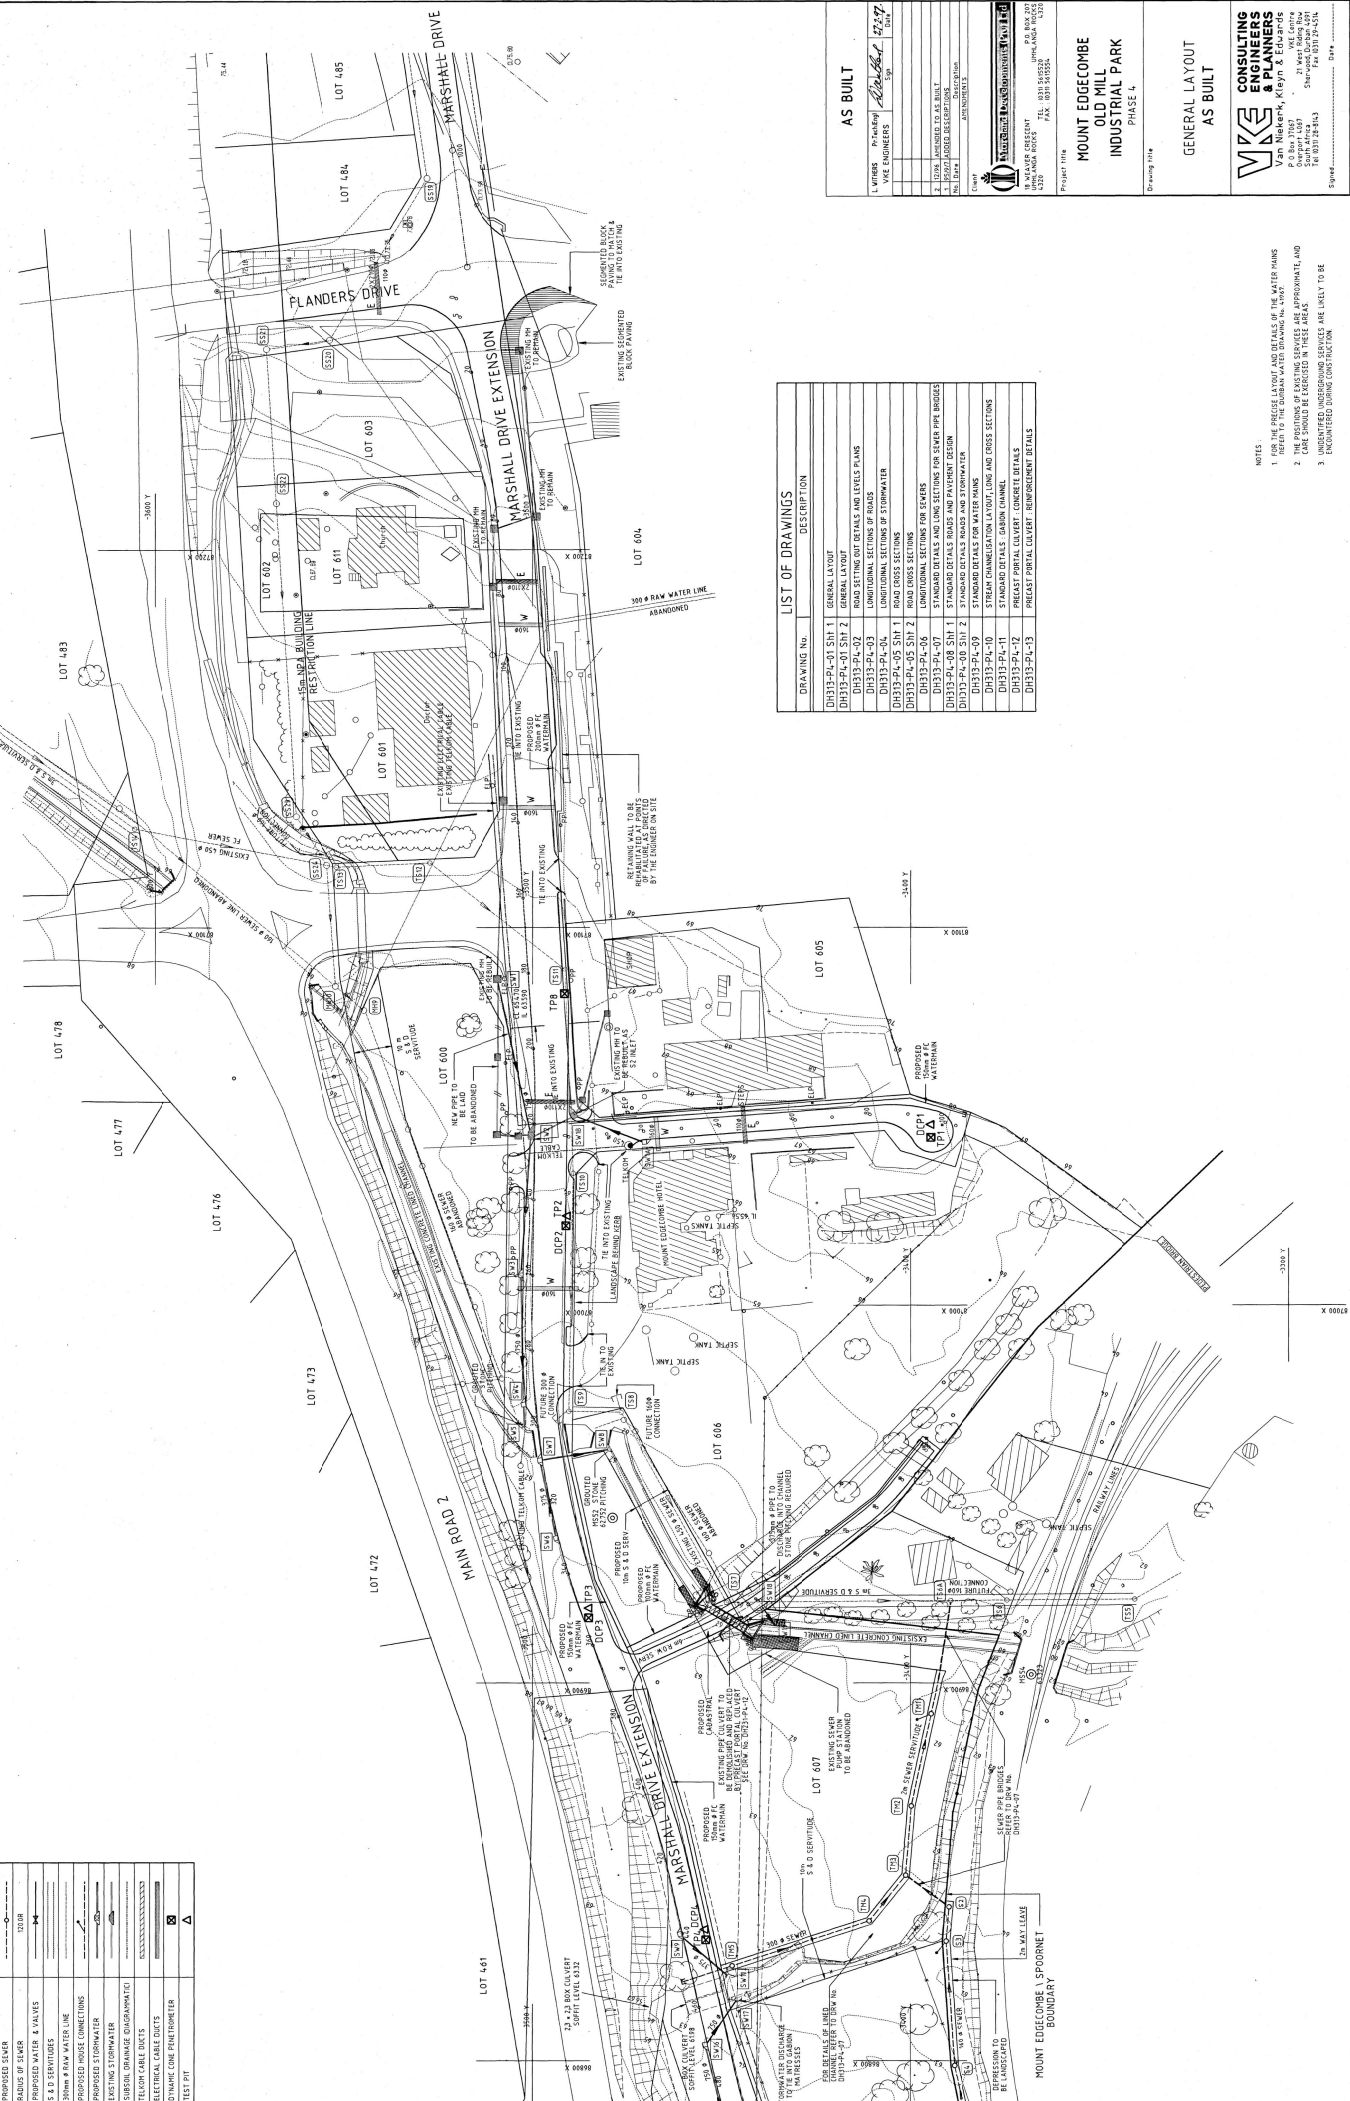

DRAWING No.	DESCRIPTION
DH133-PA-01 SH1 1	GENERAL LAYOUT
DH133-PA-02 SH1 2	ROAD SET OUT DETAILS AND LEVELS PLANS
DH133-PA-03	ROAD SET OUT DETAILS AND LEVELS PLANS
DH133-PA-04	LONGITUDINAL SECTIONS OF ROADS
DH133-PA-05 SH1 1	ROAD CROSS SECTIONS
DH133-PA-05 SH1 2	ROAD CROSS SECTIONS
DH133-PA-06	LONGITUDINAL SECTIONS FOR SEWERS
DH133-PA-07	LONGITUDINAL SECTIONS FOR STORMWATER
DH133-PA-08 SH1 1	STANDARD DETAILS ROADS AND PAVEMENT DESIGN
DH133-PA-08 SH1 2	STANDARD DETAILS ROADS AND PAVEMENT DESIGN
DH133-PA-09	STANDARD DETAILS FOR WATER MAINS
DH133-PA-10	STANDARD DETAILS GROUND CHANNEL
DH133-PA-11	STANDARD DETAILS FOR WATER MAINS
DH133-PA-12	STANDARD DETAILS FOR WATER MAINS
DH133-PA-13	PRECAST PERIAL CULVERT REINFORCEMENT DETAILS

- NOTES
1. THE POSITION OF EXISTING SERVICES ARE APPROXIMATE, AND CARE SHOULD BE EXERCISED IN THESE AREAS.
 2. THE POSITIONS OF EXISTING SERVICES ARE APPROXIMATE, AND CARE SHOULD BE EXERCISED IN THESE AREAS.
 3. UNDETERMINED DURING CONSTRUCTION.

AS BUILT

VICE PRESIDENT: *[Signature]*
 VICE ENGINEERS: *[Signature]* 27/27
 DATE: 2013

AS BUILT
 PROJECT TITLE: **MOUNT EDGEcombe OLD MILL INDUSTRIAL PARK PHASE 4**
 GENERAL LAYOUT AS BUILT
 DRAWING No.

MKS CONSULTING ENGINEERS & PLANNERS
 Van Niekerk, Klyn & Edwards
 6-8 Bona Vista
 23 West Coast
 7901 Cape Town
 Tel: 021 935 9333
 Fax: 021 935 9334

PROJECT No. 1301
 DRAWING No. 1301-01
 SHEET No. 1
 OF 1

DATE: 2013
 DRAWN BY: [Name]
 CHECKED BY: [Name]
 APPROVED BY: [Name]