




MANAGERS QUARTERS
SCALE 1:100

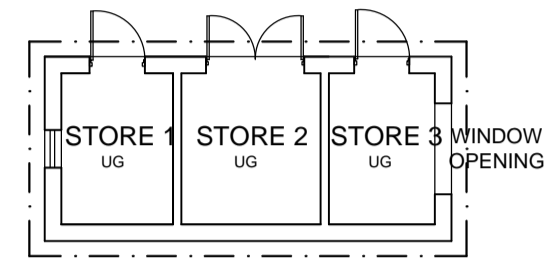


SMALL STORES
SCALE 1:100

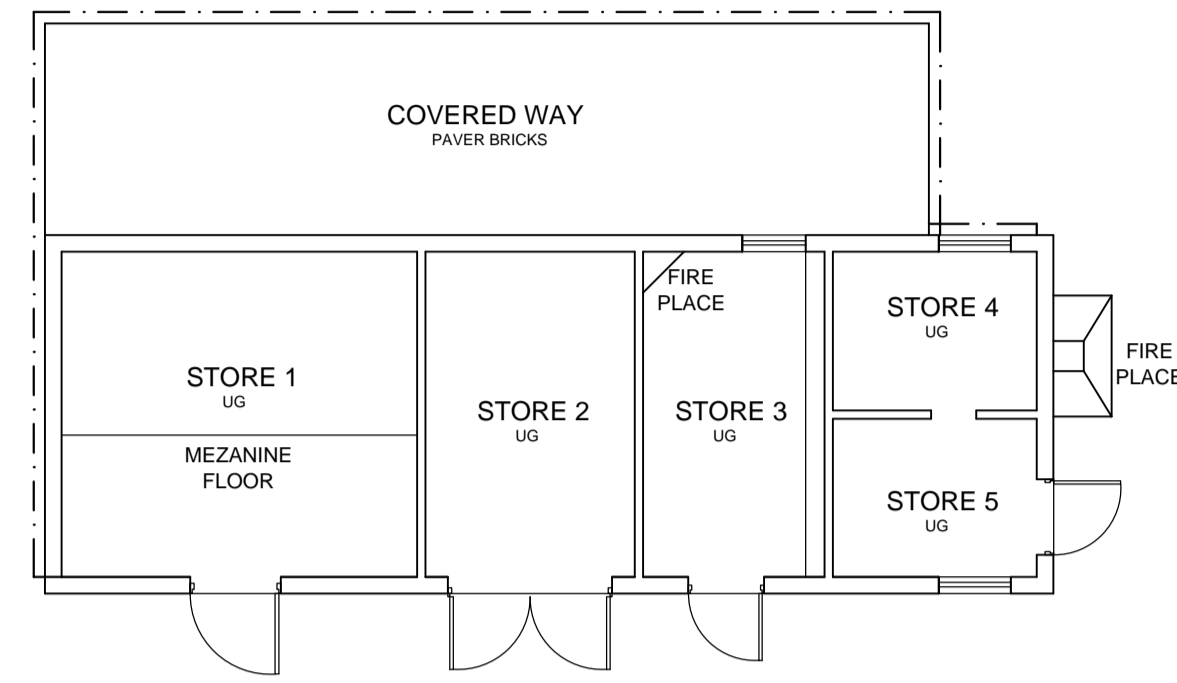


ROASTERY
SCALE 1:100

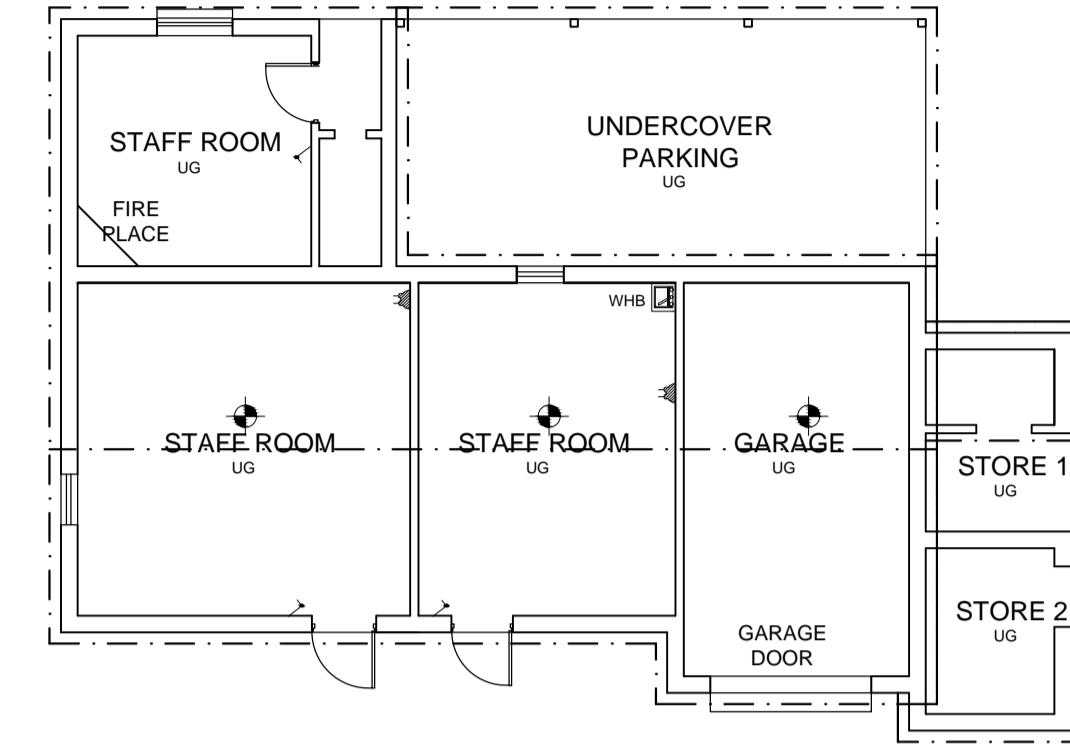

STAFF QUARTERS / GARAGE
SCALE 1:100

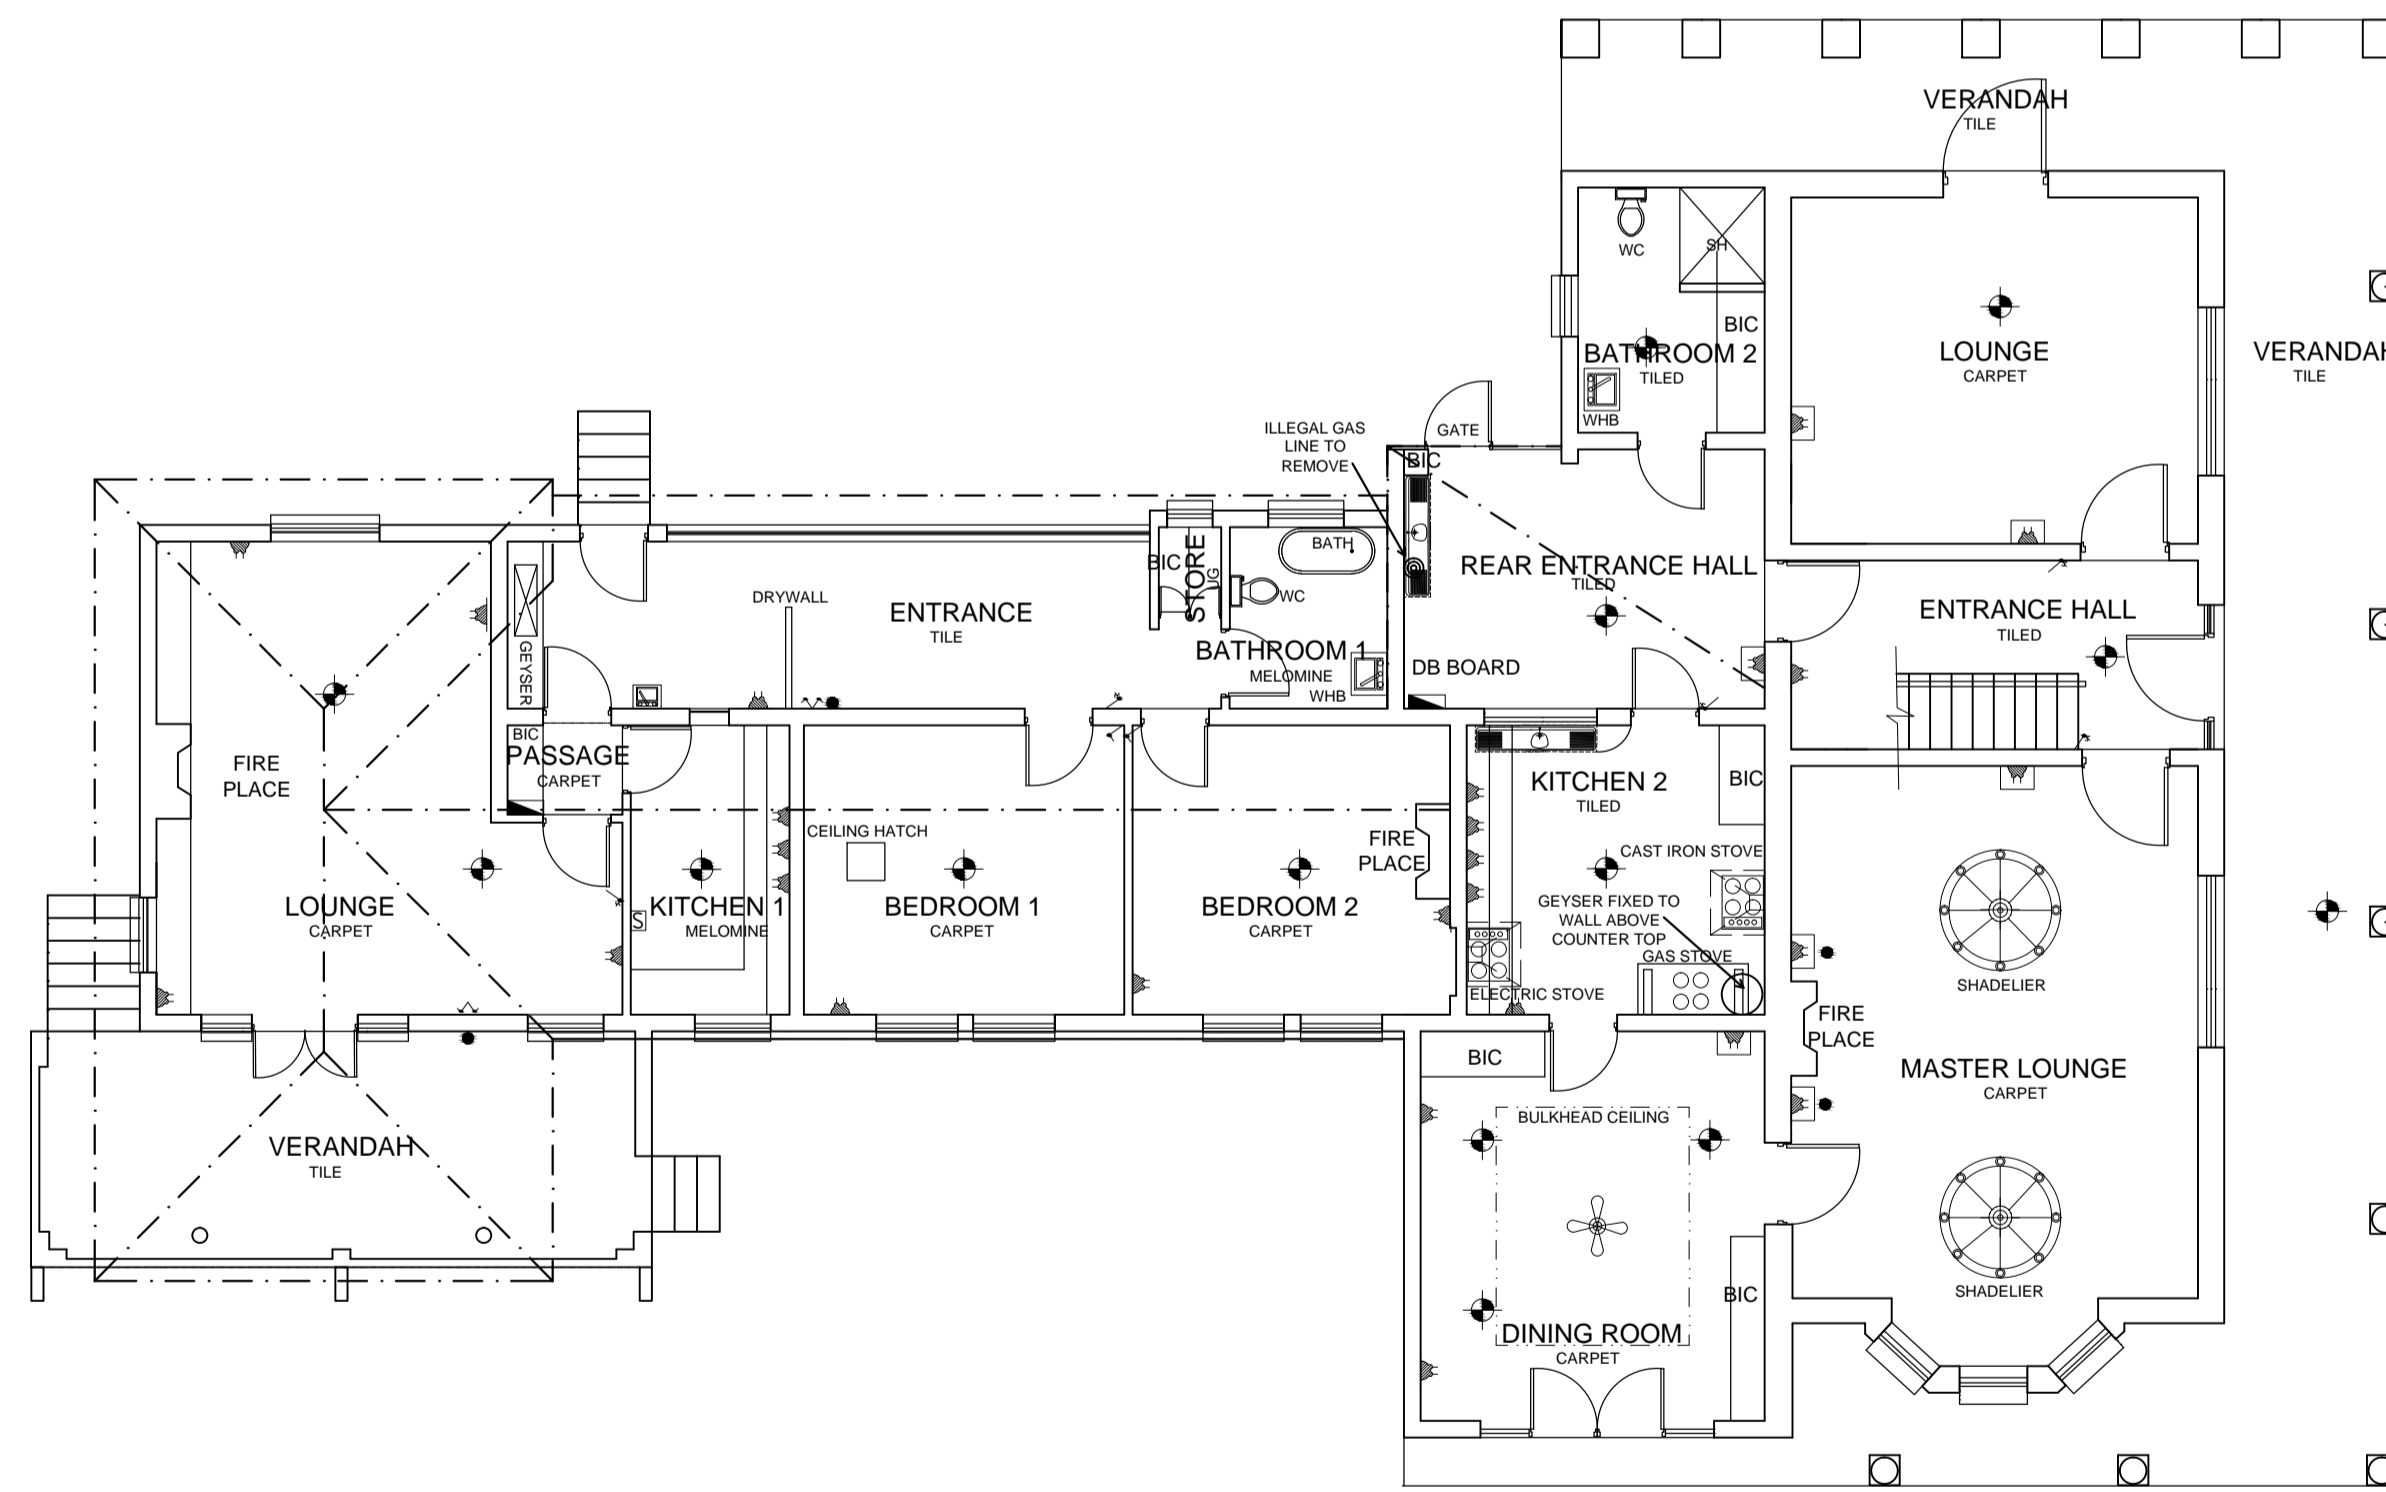

MAIN HOUSE GROUND FLOOR
SCALE 1:100

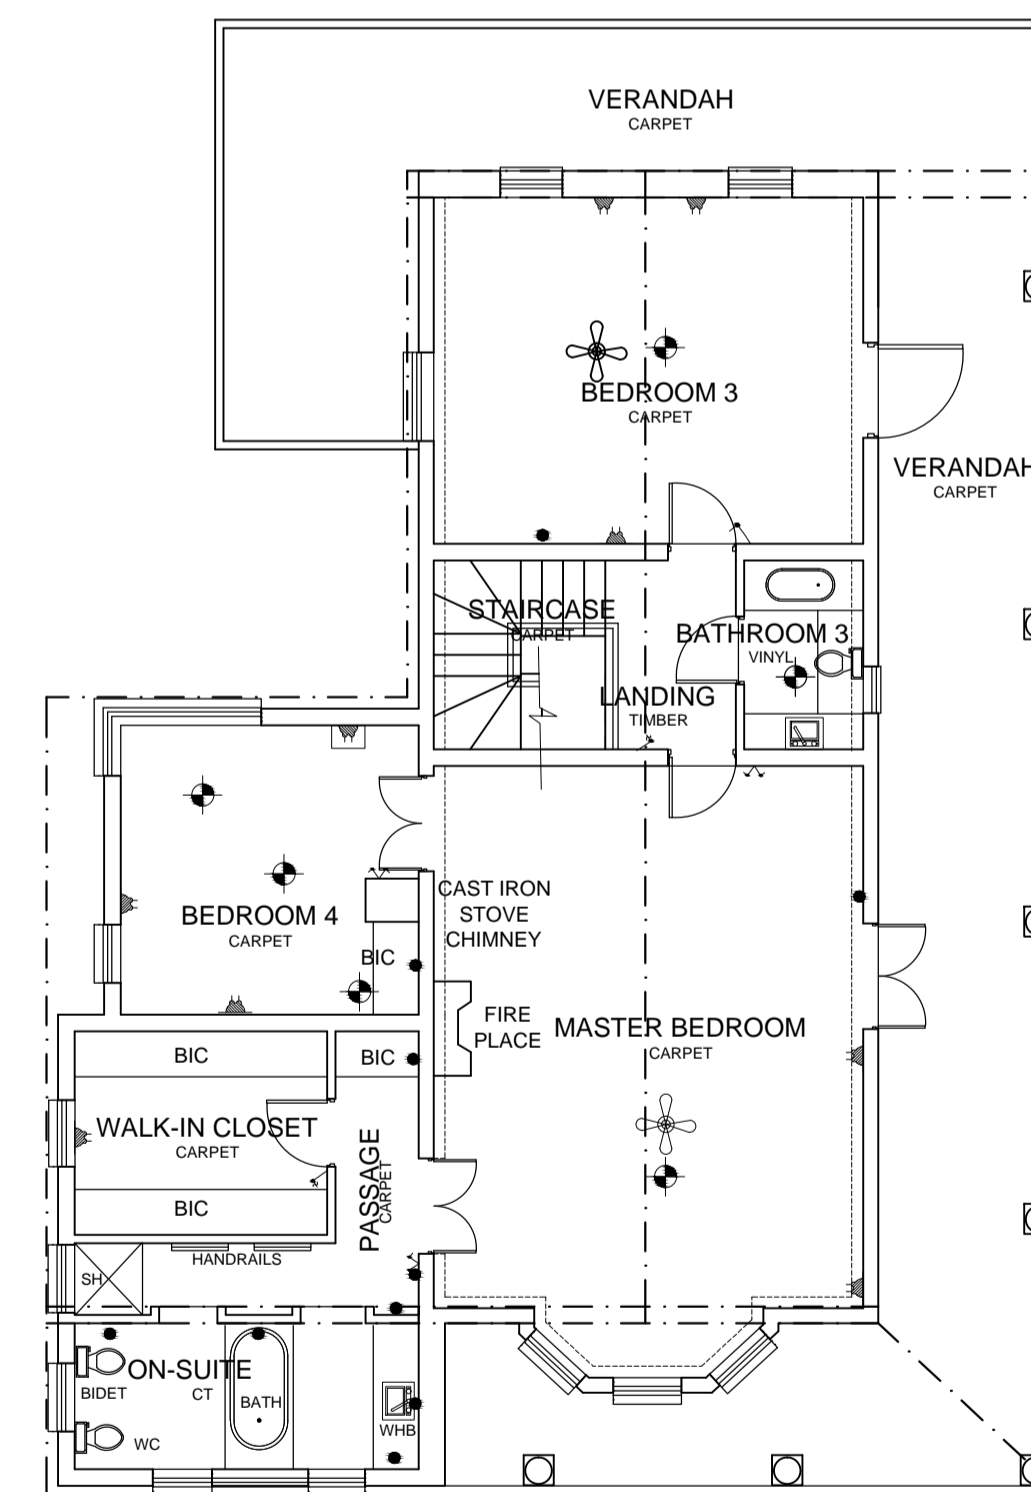

MAIN HOUSE FIRST FLOOR
SCALE 1:100

AREA	
MAIN HOUSE GROUND FLOOR	382.26m ²
MAIN HOUSE FIRST FLOOR	224.68m ²
MANAGERS QUARTERS	20.21m ²
STAFF QUARTERS / GARAGE	105.72m ²
ROASTERY	95.35m ²
SMALL STORES	13.12m ²
OUTSIDE TOILET	2.00m ²
TOTAL	843.94m²

ELECTRICAL LEGEND	
	DP1 - DP27
	DOP1 - DOP5
	CL1 - CL4
	SO 1
	LS1 - LS7
	DLS1 - DLS2
	2LS1 - 2LS9
	TPO 1
	TV1
	BD1
	BHF1-BHF4
	DS1