

SHEET // COPY 3

CITY OF DURBAN

PLAN NUMBER 417/8/82

APPROVED 16 MAY 1983

DATE

G. C. MACLEOD CITY ENGINEER

Any person undertaking building operations in accordance with this plan is required to ascertain from the City Electrical Engineer the location of underground cables in the vicinity of the proposed works prior to commencement thereof.

TOWN PLANNING BRANCH

APPROVED

DATE 25 AUG 1982

Signature

IMPORTANT

APPLICATION FOR REFUND OF PORTION OF BUILDING FEES ON ABANDONED PLANS MUST BE RECEIVED BY THE CITY ENGINEER'S DEPARTMENT NOT LATER THAN THIRTY (30) DAYS AFTER THE EXPIRY DATE OF APPROVAL OF THIS PLAN.

NOTE





NO TAP WATER MAY BE USED IN THE FILLING OR TOPPING UP OF SWIMMING POOLS

AS BUILT


83/07/28

DRAWN BY: F. S. Charlis

DATE: 6th July 1982.

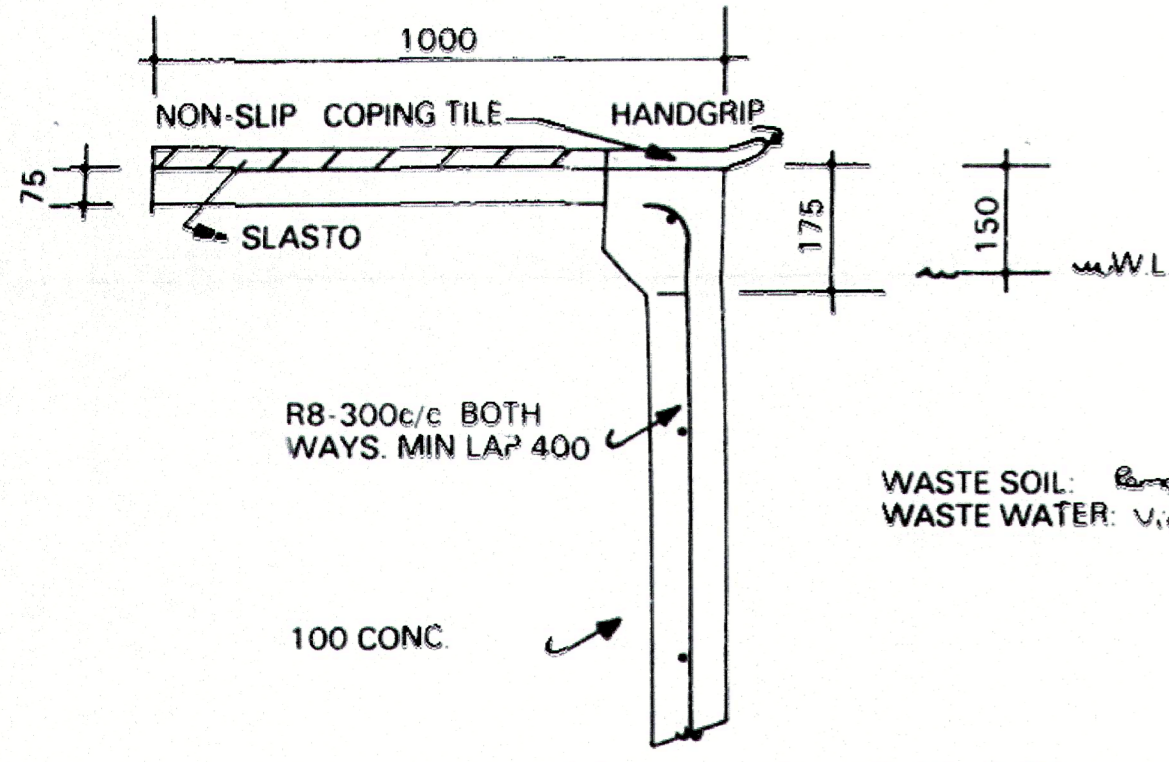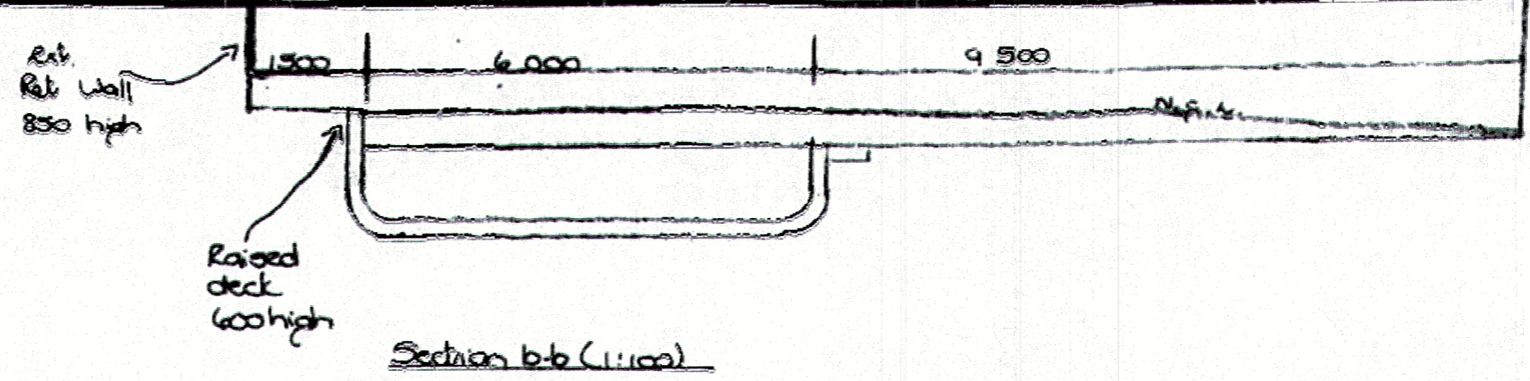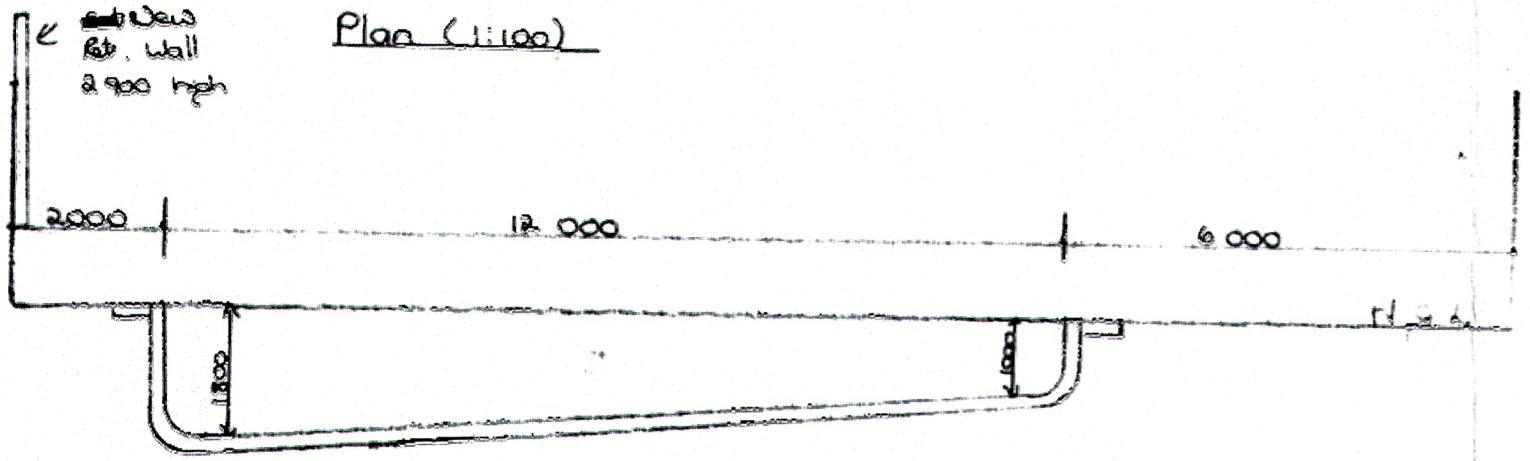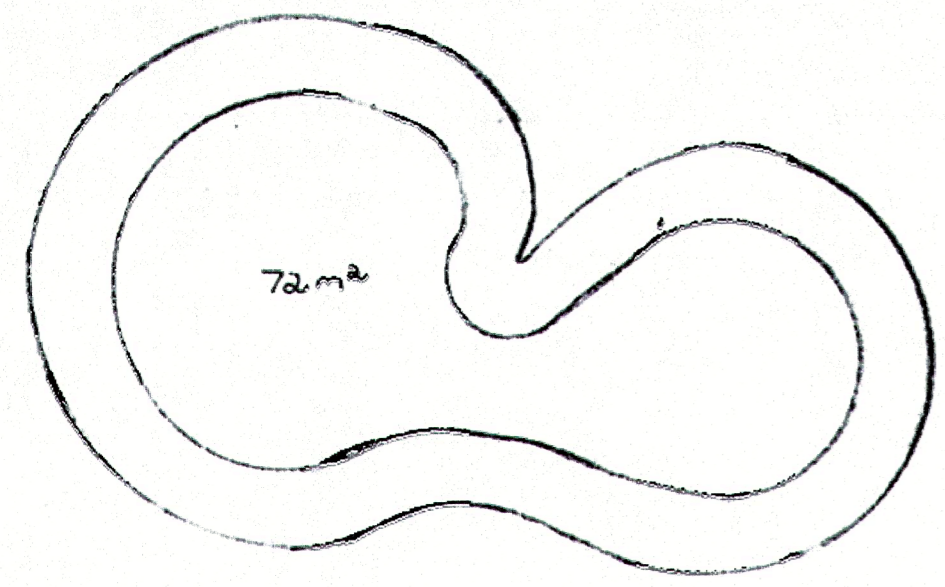

WASTE SOIL: Removed from site.
WASTE WATER: Via B.P.T. to S.C. Sewer

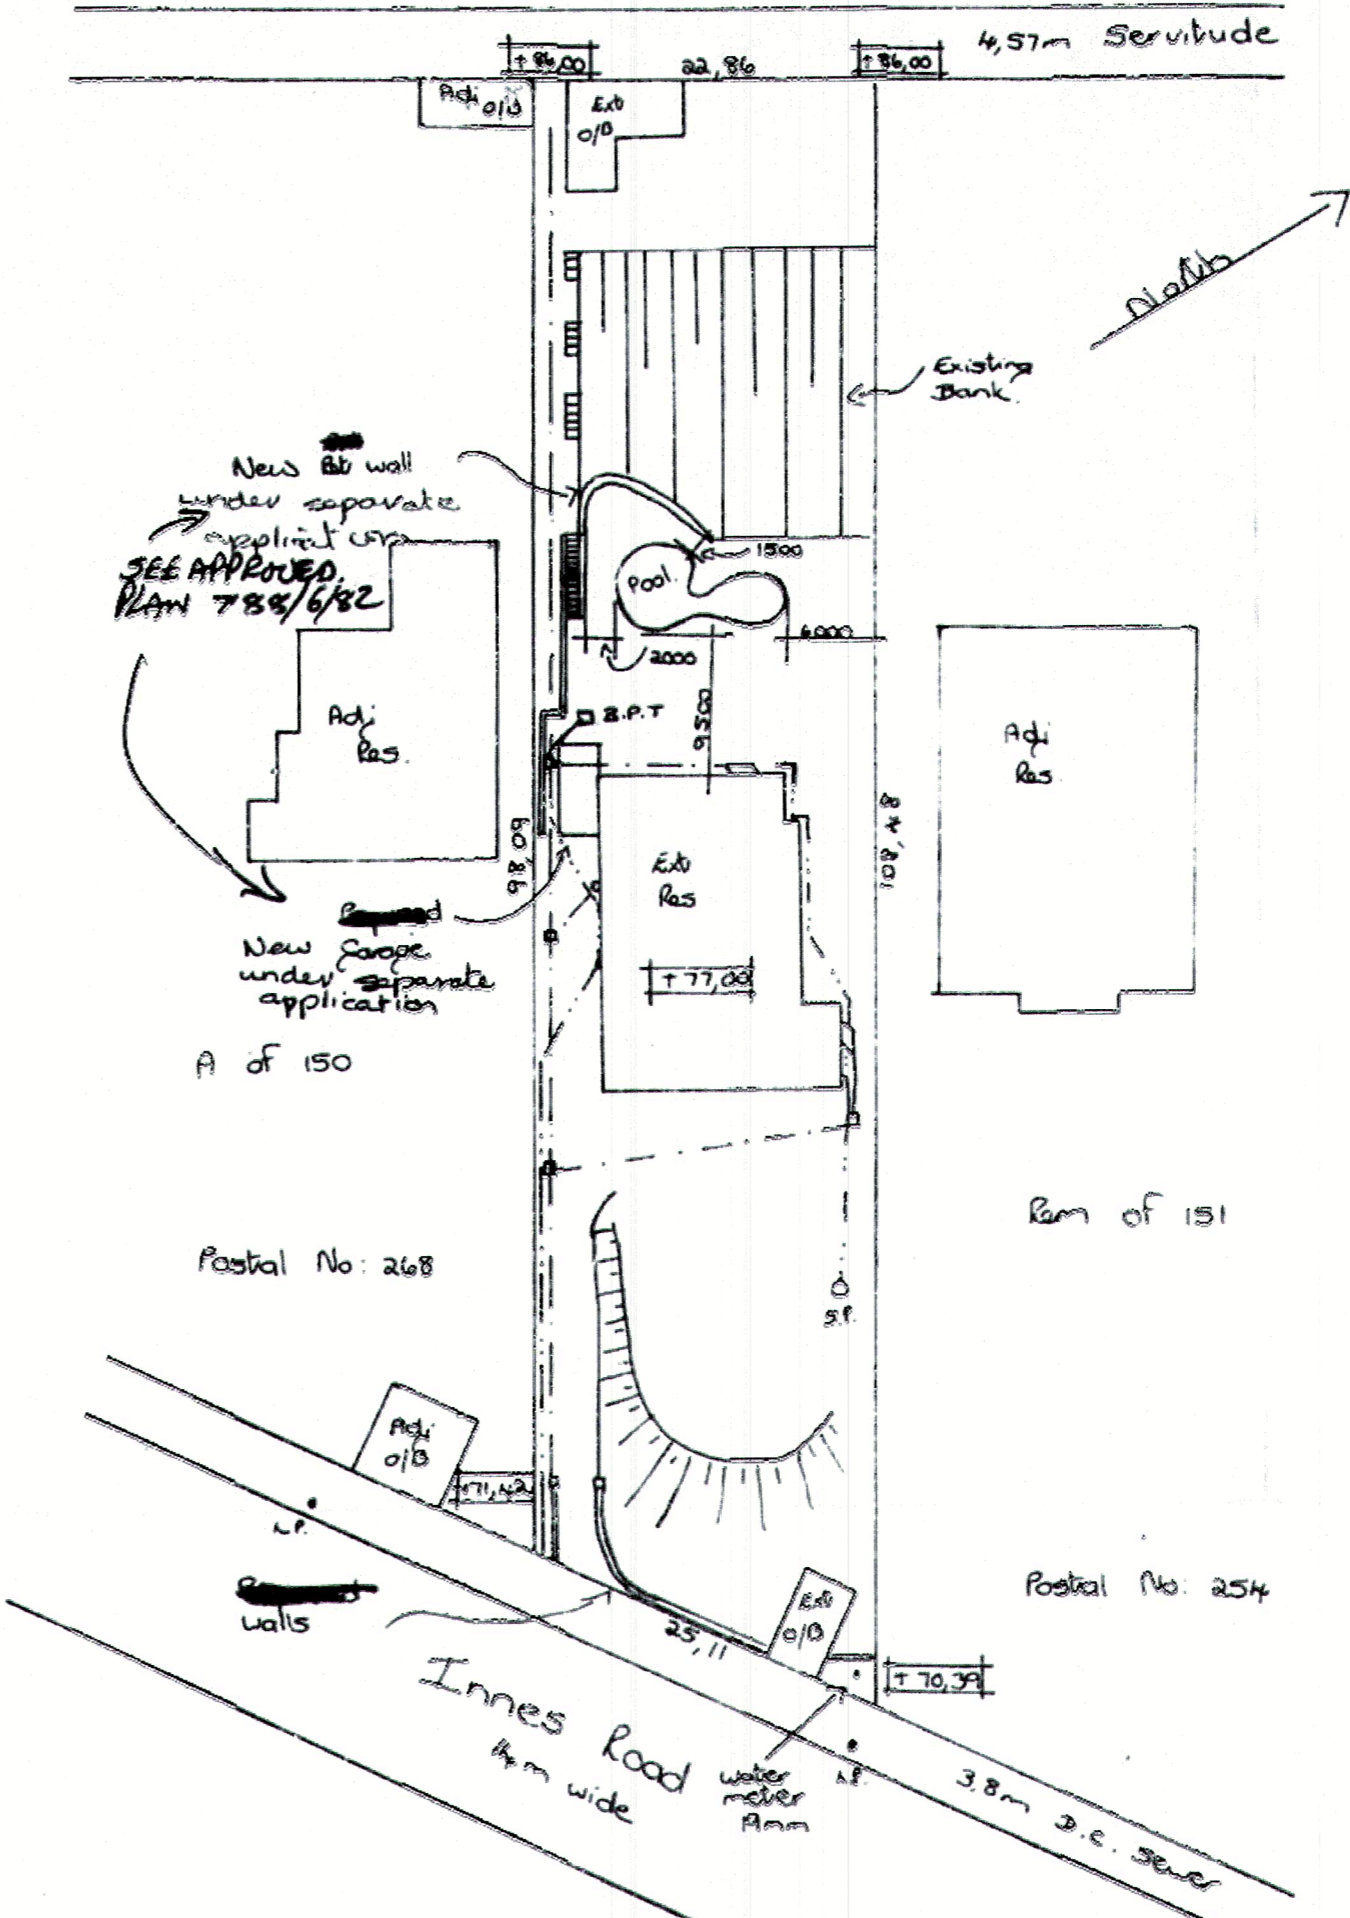

site plan (1:500)
Sub A of 151 of Block D
Townlands of Durban 737.

- earth leakage protection to be fitted on electrical supply.
- precautions to be taken in regard to condensate.
- pump chamber to be adequately drained.
- electrical equipment to be housed.

SPARKLING POOLS
194c UNDERWOOD Rd.
PINETOWN 3600
Phone 782572 782888

proposed pool for:-
Mr T.S. Cairns
260 Innes Road
Durban

- kerb & pool in 100 gunite monolithically & pneumatically placed.
- mix: 1 part cement : 4 parts washed umgeni sand.
- path is not integral with pool.

Rate Numbers: 19332