

# Mutsho Solar Power Project Limpopo Province

Locality Map


## Legend

- Towns
- Eskom Substation
- Existing Power Line
- Main Road
- National Road
- Regional Road
- Perennial River
- Non-Perennial River
- Railway Line
- Project Site

Scale: 1: 210 107  
Projection: WGS\_GCS\_1984  
Map Ref: Mutsho - PV Facility





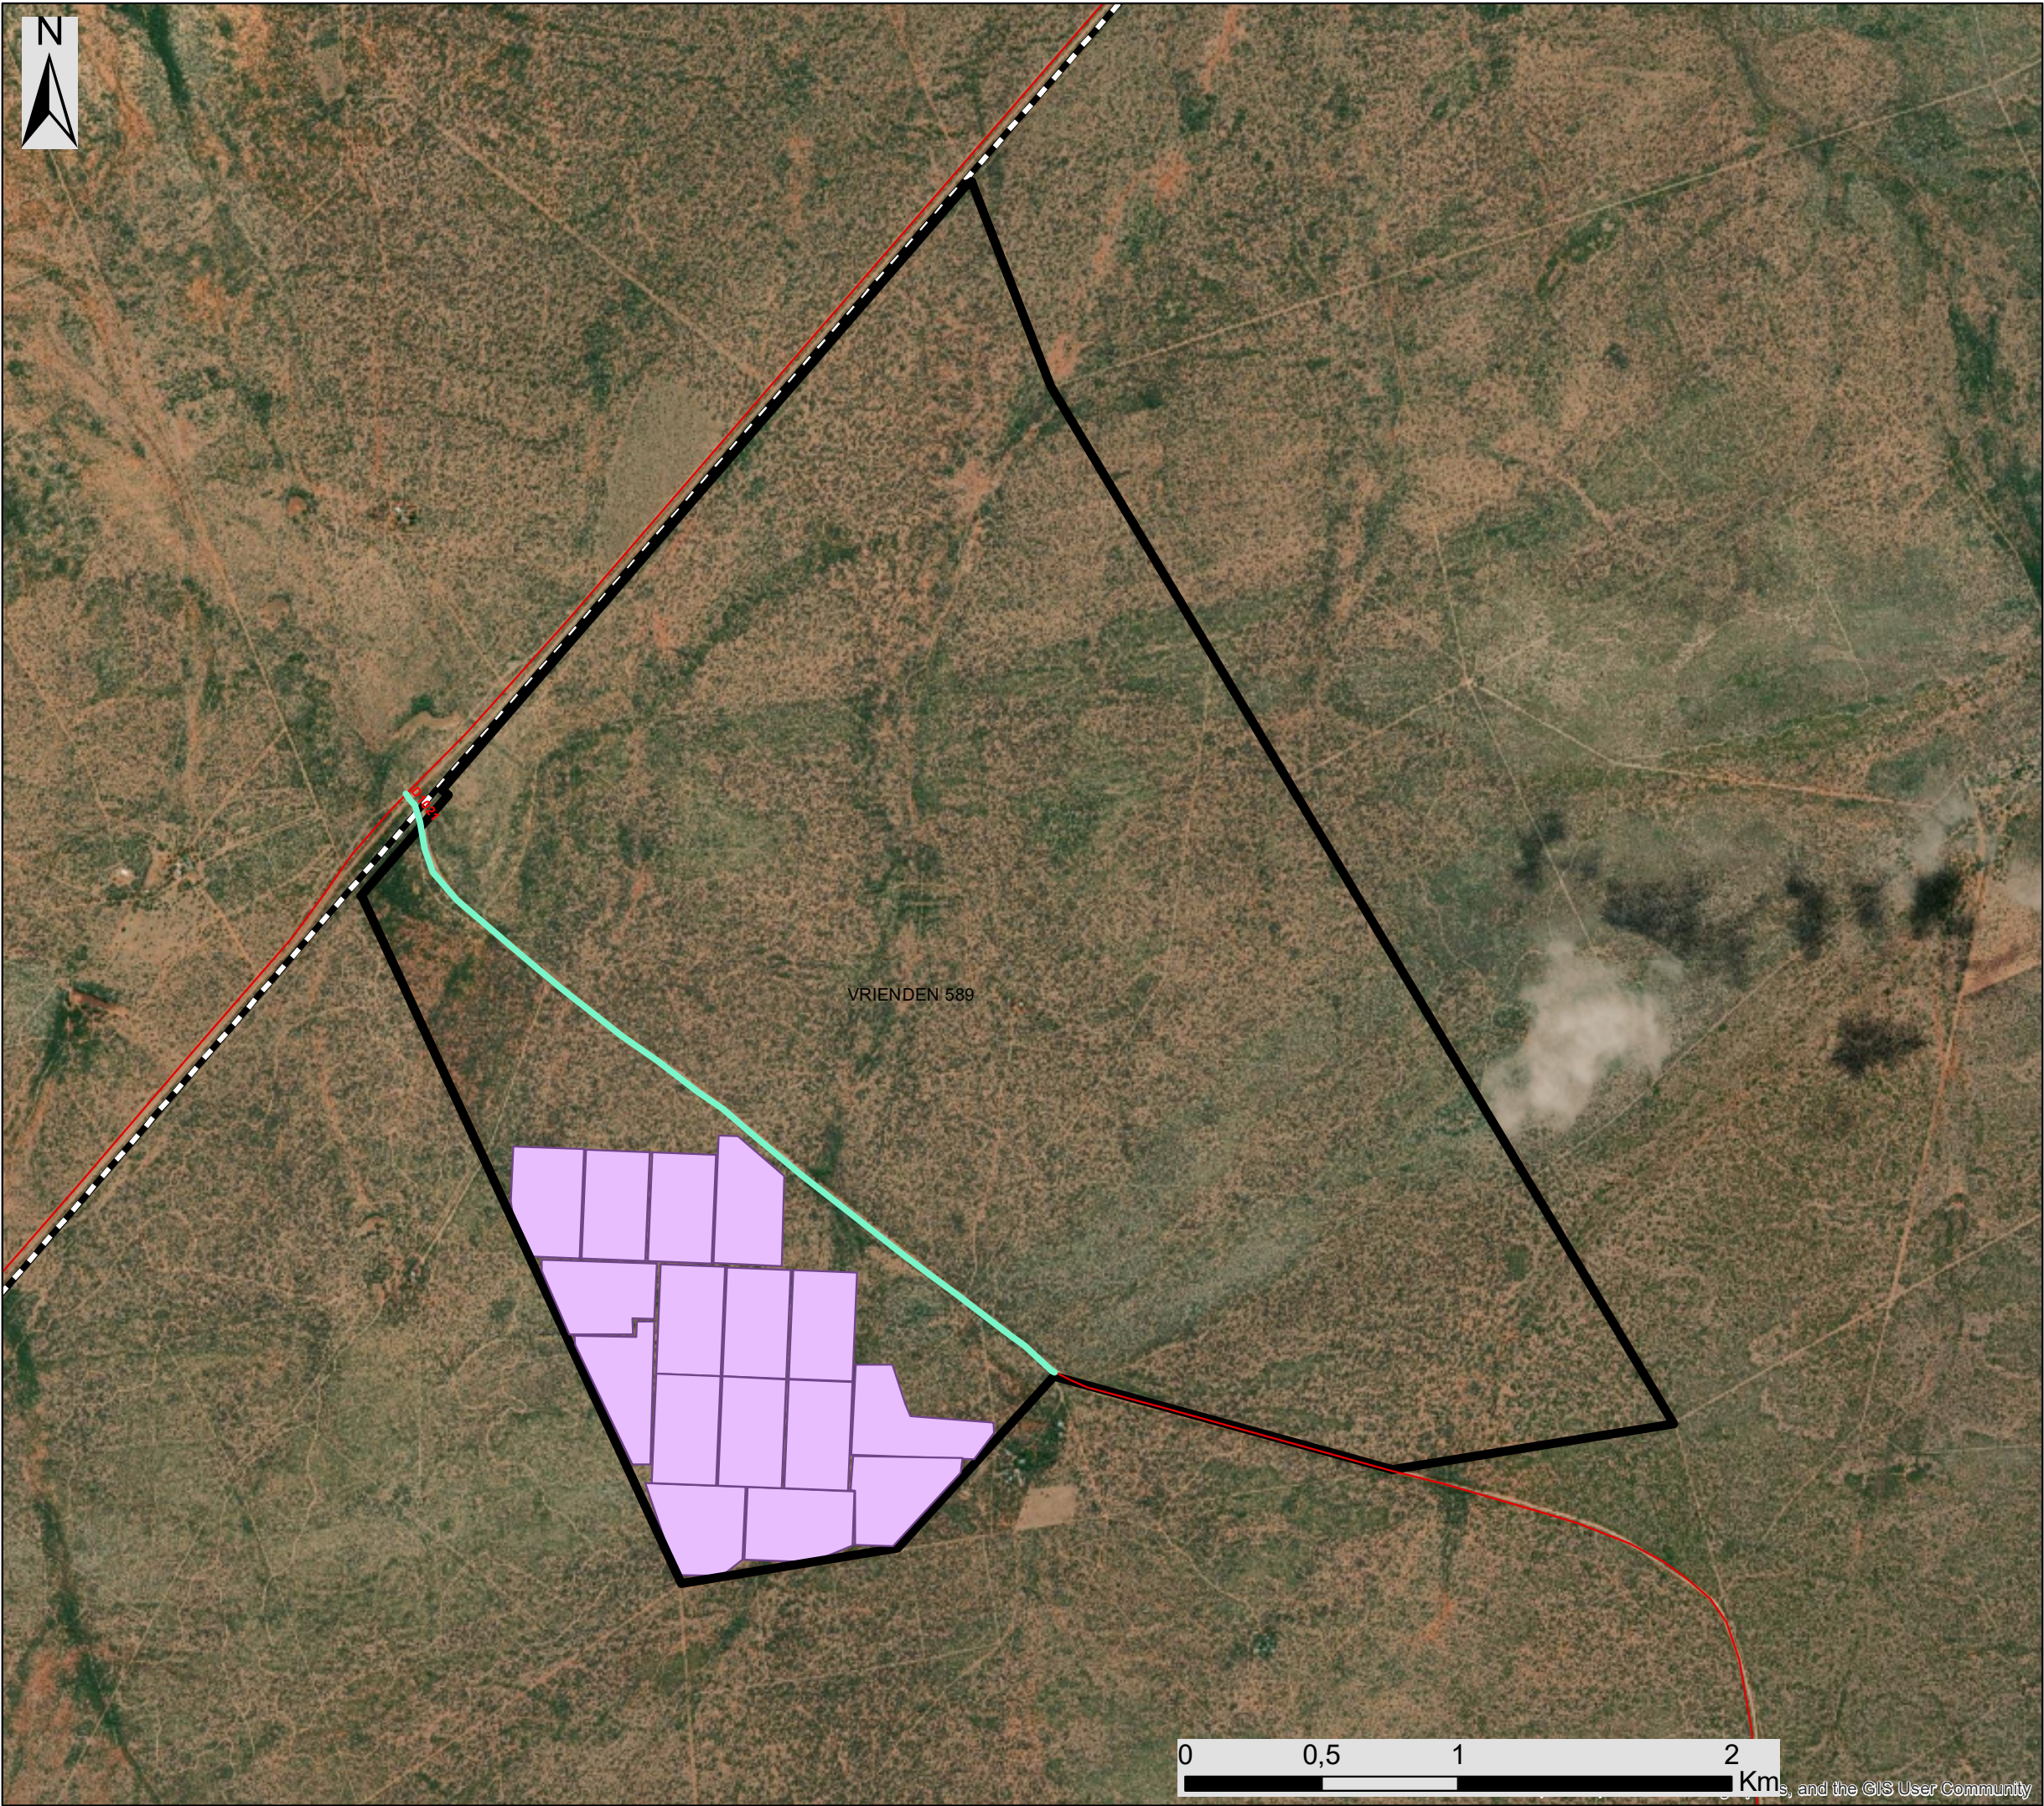

# Mutsho Solar PV4 Limpopo Province

Layout Map

## Legend


- Eskom Substation
- Existing Power Line
- Main Road
- National Road
- Railway Line
- Existing Access Road
- ▭ Project Site
- ▭ Mutsho Solar PV4

Scale: 1: 210 107  
Projection: WGS\_GCS\_1984  
Map Ref: Mutsho - PV Facility

savannah  
environmental





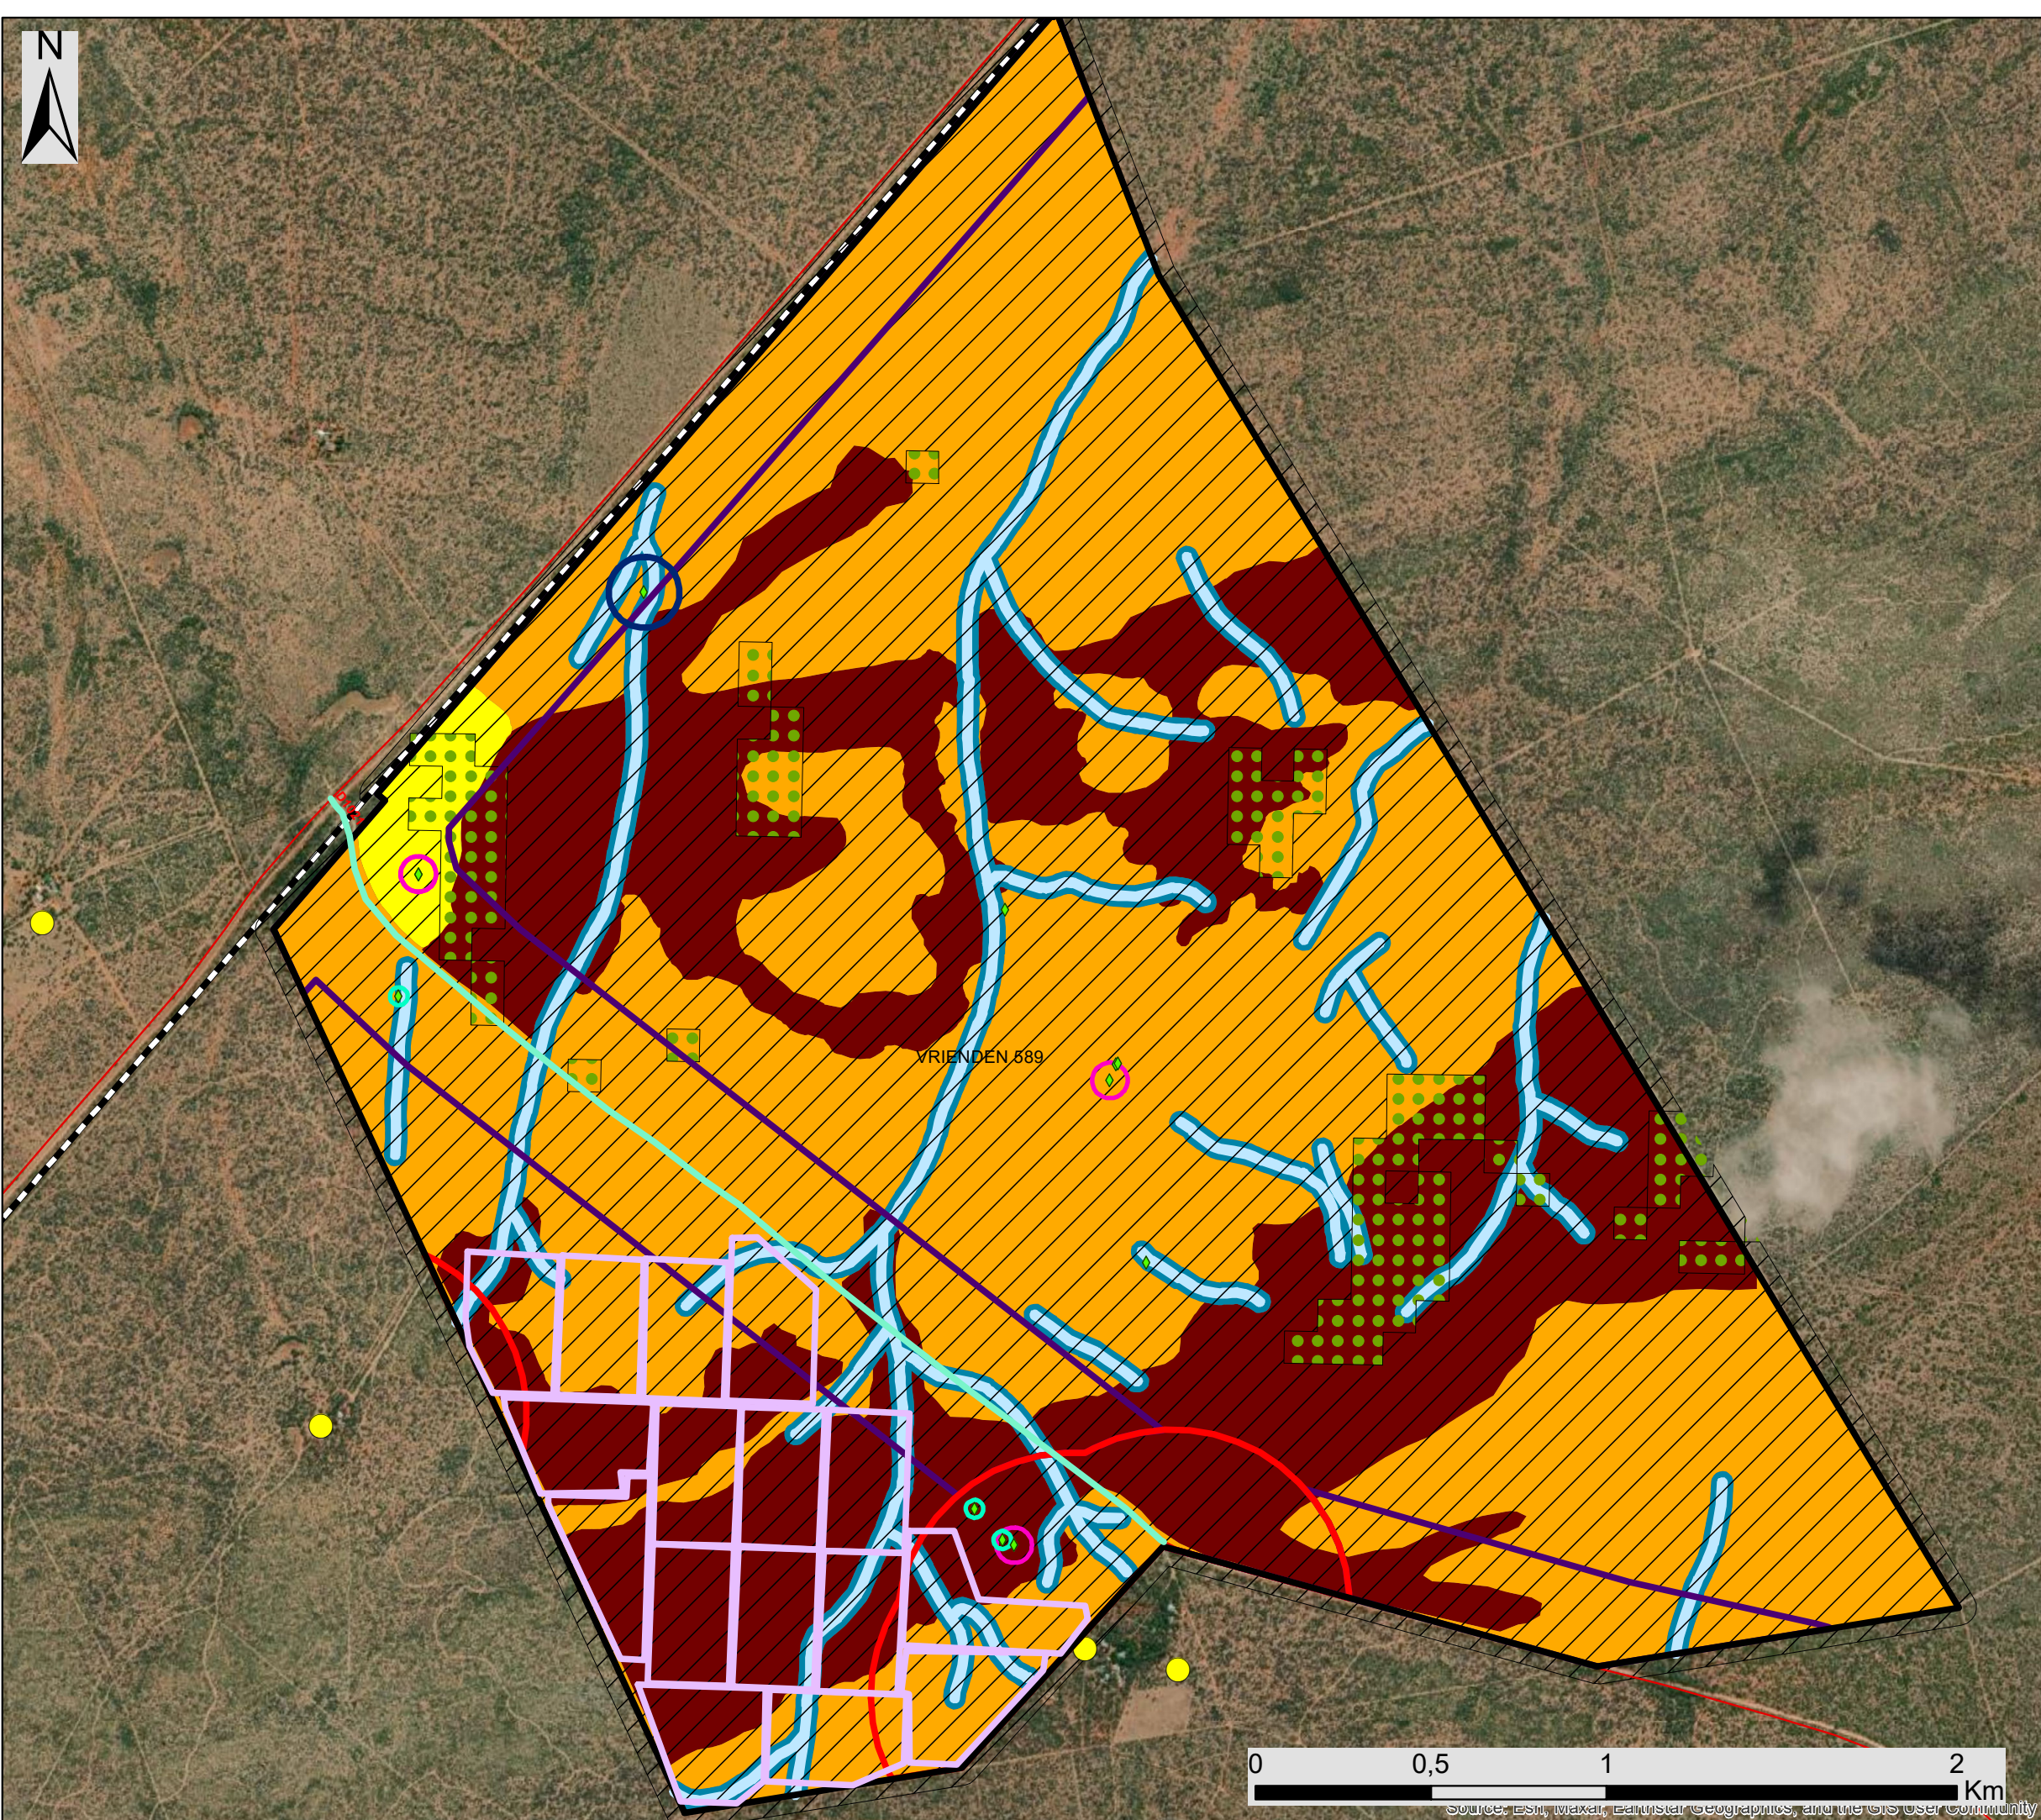

# Mutsho Solar Power Project Limpopo Province

## PV4 Layout and Sensitivity Map


- Legend**
- Railway Line
  - Main Road
  - Existing Access
  - Project Site
  - Mutsho Solar PV4
- Heritage Sensitivity**
- Heritage Sites
  - Heritage Buffer 50m
  - Heritage Buffer 100m
  - Heritage Buffer 200m
- Visual Sensitivity**
- Homesteads (500m Buffer)
  - D1021 (500m Buffer)
  - Homesteads (High Visual Sensitivity)
  - Main Road
- Ecological Sensitivity**
- Closed Woodland (High Ecological Sensitivity)
  - Mopane Bushveld (Medium Ecological Sensitivity)
  - Rocky Area (Medium Ecological Sensitivity)
  - Watercourse 30m Buffer (Pre-Mitigation) (High Ecological Sensitivity)
  - Watercourse 15m Buffer (Post Mitigation) (High Ecological Sensitivity)
- Soils & Agricultural Potential**
- Medium Land Capability
  - Low Land Capability

Scale: 1: 210 107  
Projection: WGS\_GCS\_1984  
Map Ref: Mutsho - PV Facility

**savannah**  
environmental





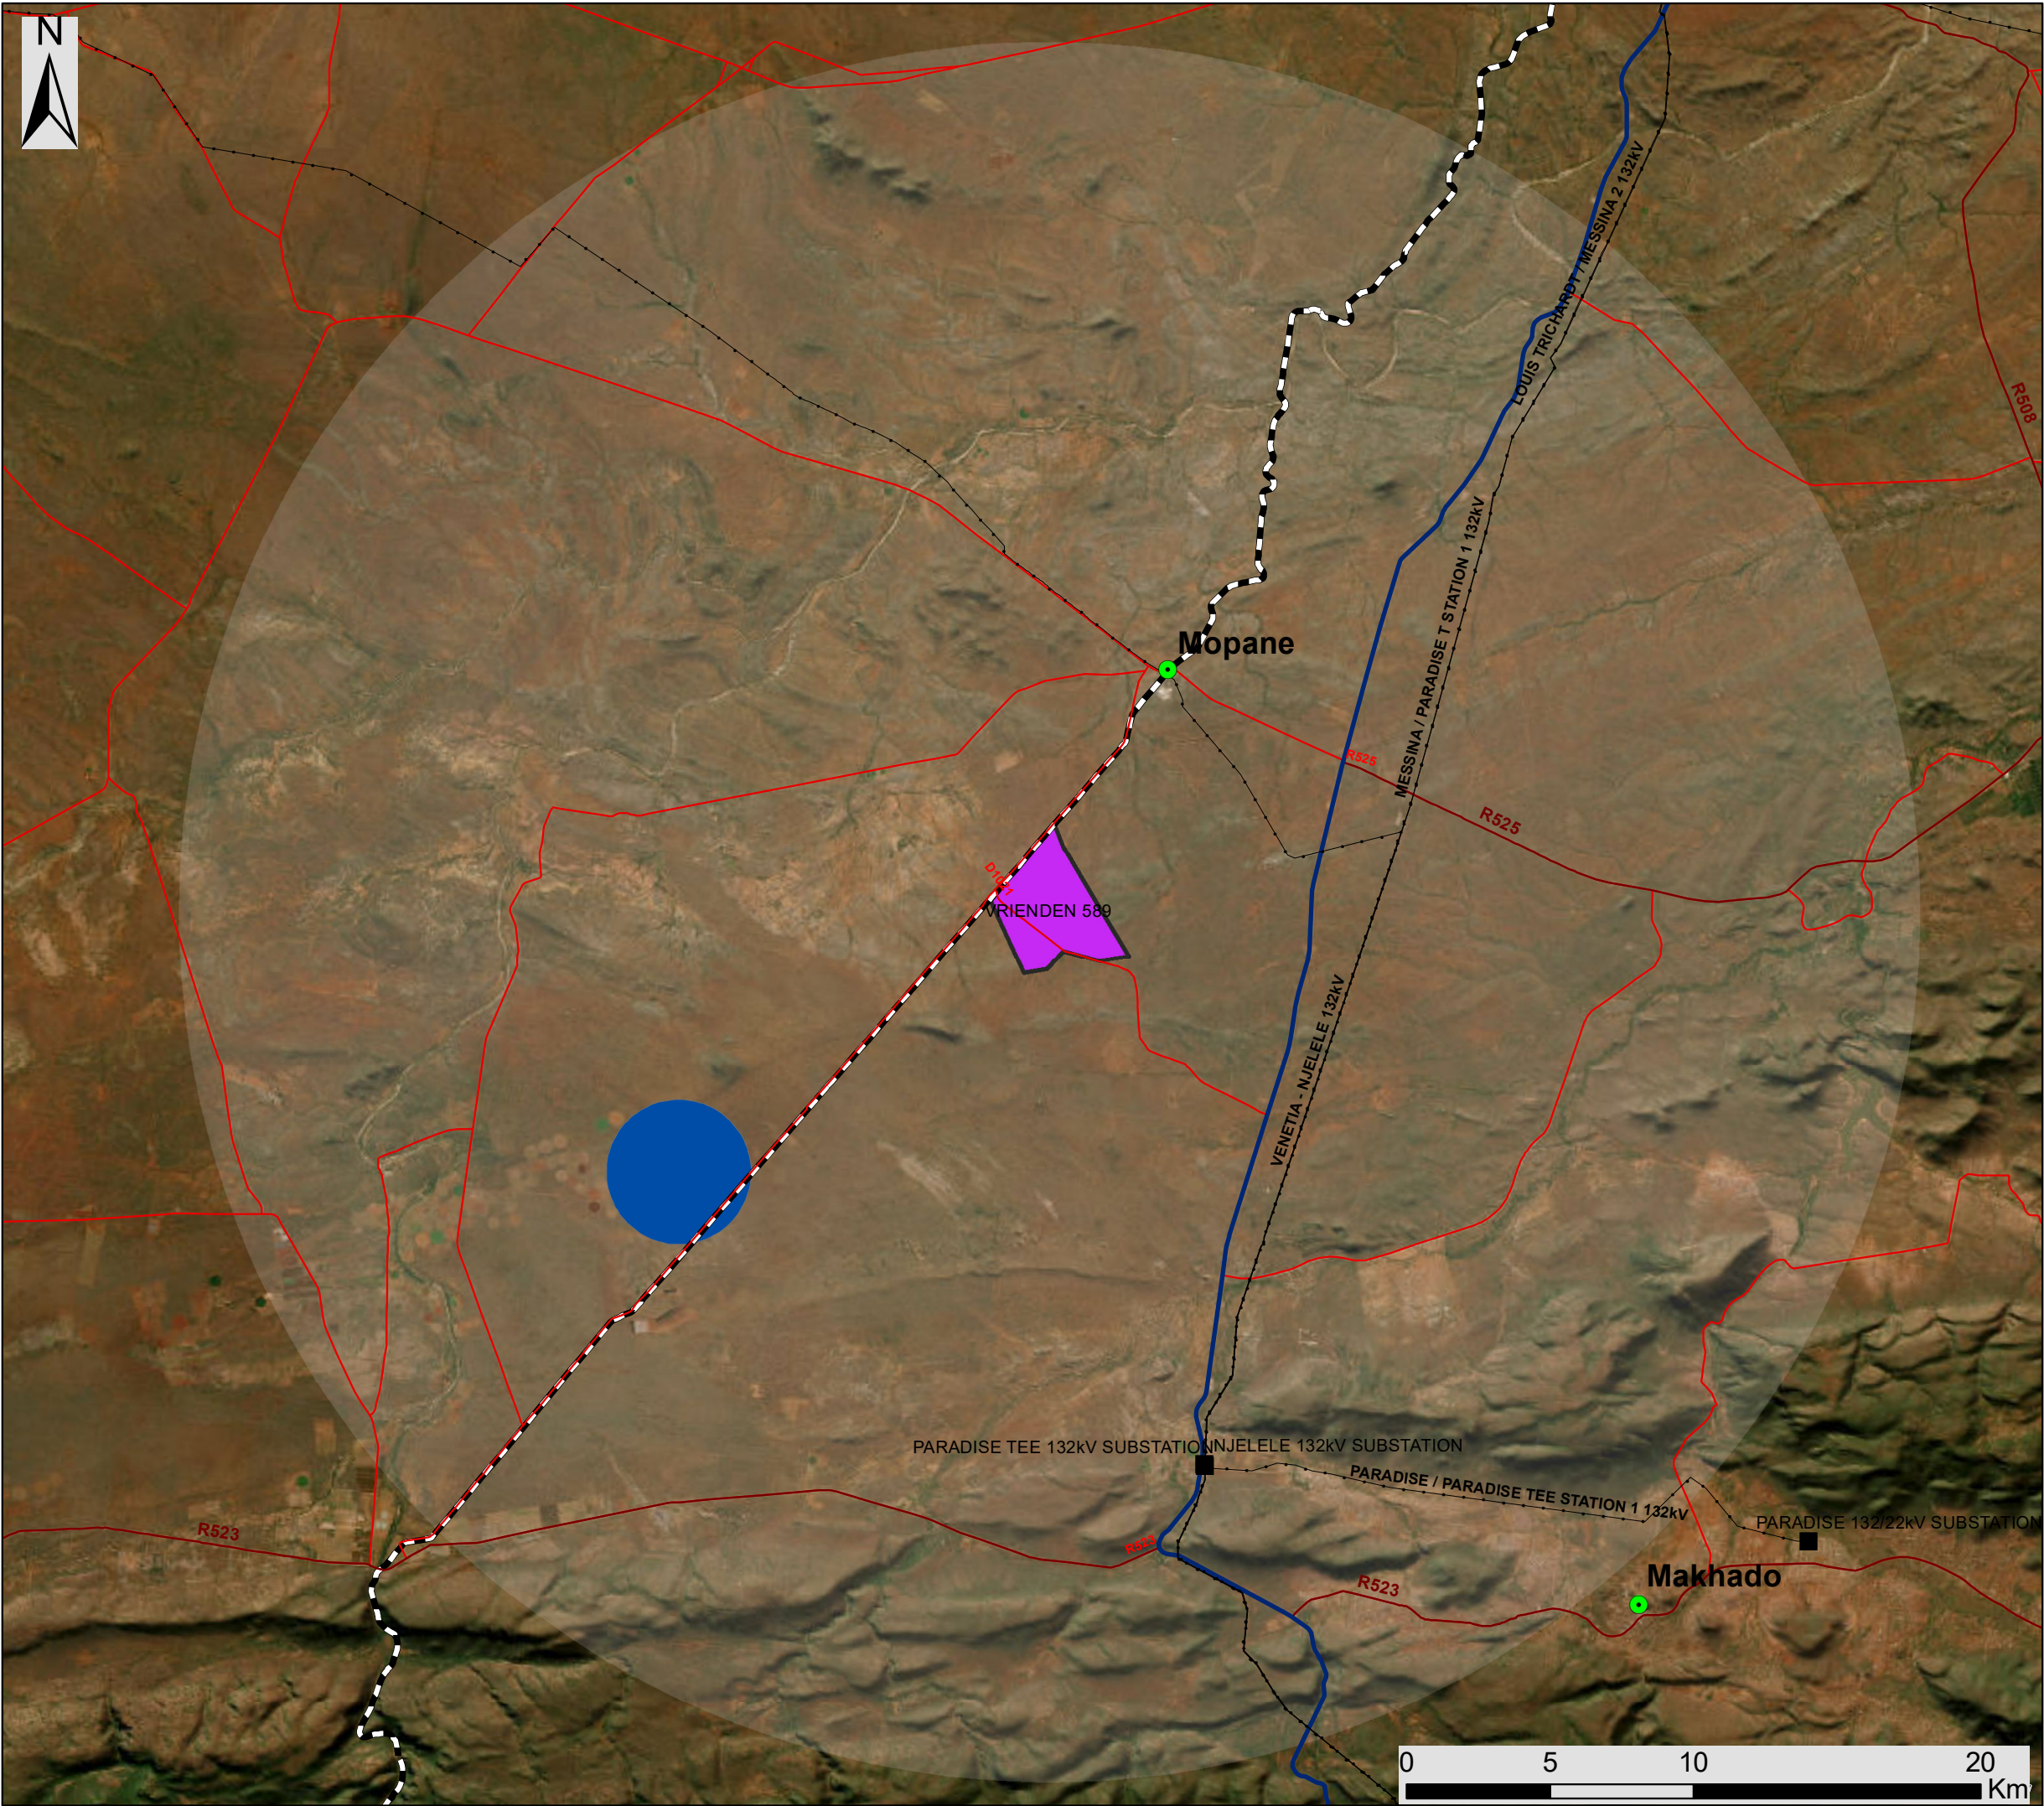

# Mutsho Solar Power Project Limpopo Province

Cumulative Map

## Legend

- Towns
- Eskom Substation
- Existing Power Line
- Main Road
- National Road
- Regional Road
- Railway Line

- Project Site
- DFFE 30km Buffer

## Other Known Renewable Energy Facility (REEA 2022 Q3)

- ABC Prieska Solar 75MW  
Photovoltaic Power Plant

Scale: 1: 210 107  
Projection: WGS\_GCS\_1984  
Map Ref: Mutsho - PV Facility

