

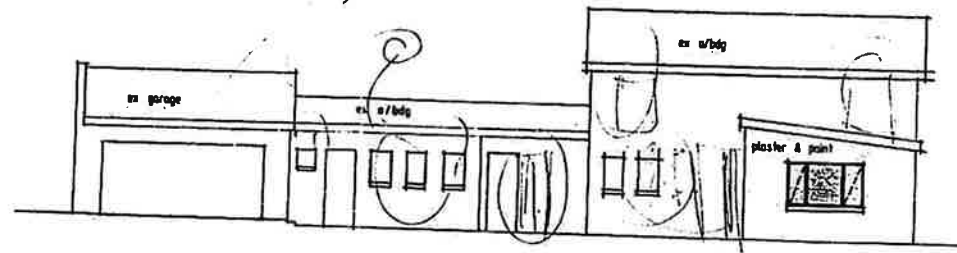


EAST ELEVATION

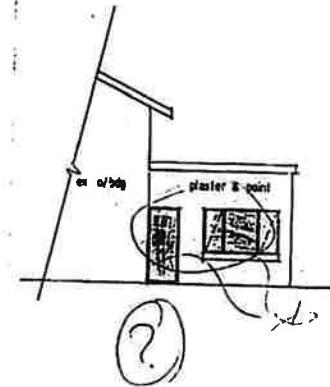


SOUTH ELEVATION

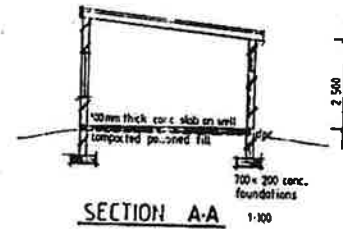


SECTION A-A

PROP STUDY @ 21m²
SITE AREA: 114m²
EX. BLDG.

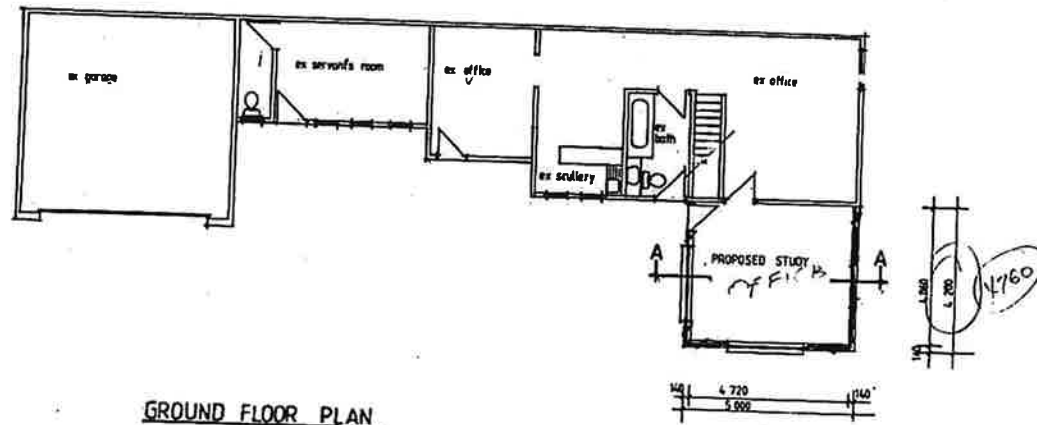

GROUND FLOOR PLAN

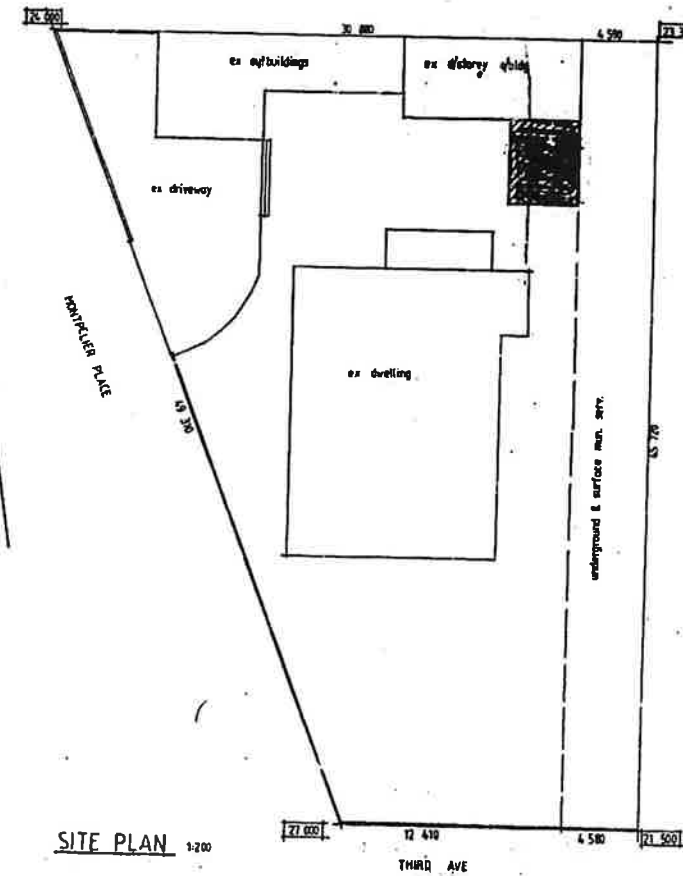

SITE PLAN

SHEET 1/1

CITY OF DURBAN

0265-0000-007

DESIGN

ELECTRICITY SUPPLIER

Any electrical work must be done in accordance with the relevant regulations and standards of the Department of Electrical Engineering, Durban.

It is the responsibility of the contractor to ensure that all electrical work is done in accordance with the relevant regulations and standards of the Department of Electrical Engineering, Durban.

PROPOSED STUDY FOR
MR C PEARSON ON
LOT 943 DURBAN
38 MONTPELIER PLACE
MORNINGSIDE DURBAN

contact: 203 1310

SUBDIVISIONS
DIVISION
SITEPLAN CHECKED
1999-04-16

SCALE: 1:200 1:200
DATE: APRIL '99
DRAWN BY: A O'NEILLY
9 MONNETTIA RD
GLENN HILLS
4057

OWNER'S SIGNATURE: