




LUMINAIRE SCHEDULE								
SYMBOL	QTY	LABEL	ARRANGEMENT	TOTAL LAMP LUMENS	LLF	DESCRIPTION	LUM. WATTS	TOTAL WATTS
	9	L <sub>2</sub>	SINGLE	TBC	TBC	BEKA SCHREDER SOLAR LEDLUME -MIDI 36LED /80W OPTIC 5118	80	720

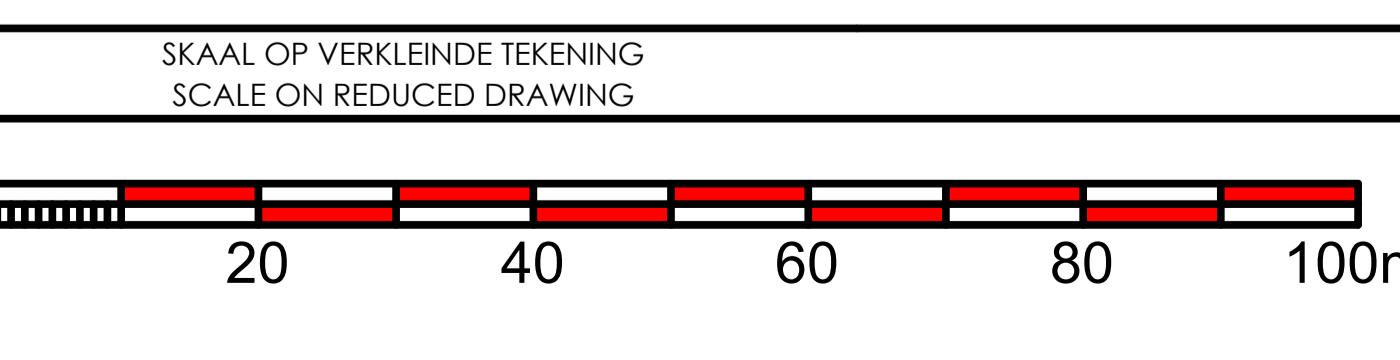

FOR INTERNAL USE:	
Designed By:	
Checked By:	T.M
Authorised By:	N.T
Drawn By:	LM
COMPANY STAMP	
nr	DATUM
No	DATE
WYSIGINGS / AMENDMENTS	

**MZIBANI**  
Consulting Engineers

MZIBANI CONSULTING  
40 CRESCENT DRIVE  
BENDOR  
POLOKWANE  
0070

**ROADS AGENCY LIMPOPO**  
Together for better roads

**ROADS AGENCY LIMPOPO**  
Contract No.: RAL/T909C/2017

REHABILITATION (DESIGN AND CONSTRUCT) OF ROAD D1484 FROM  
PONTDRIFT TO MUSINA(N1) IN VHEMBE DISTRICT OF  
LIMPOPO PROVINCE

GOEDGEKEUR DEUR APPROVED BY	DATUM DATE
n HOOF VAN DEPARTEMENT for HEAD OF DEPARTMENT	

SKAAL/SCALE AS SHOWN	VEL VAN VELLE 1 SHEET OF SHEETS
STREET LIGHTING GENERAL LAYOUT	nr: No: MCE/01/GA