
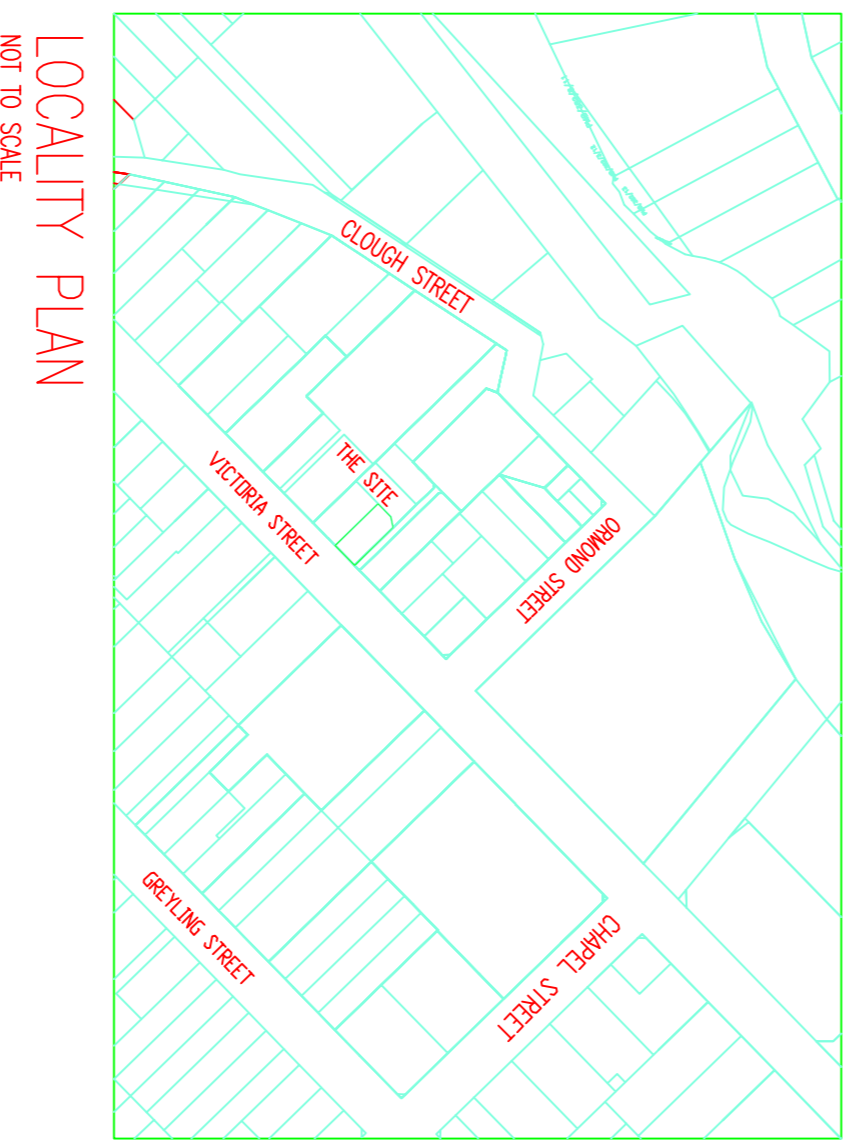
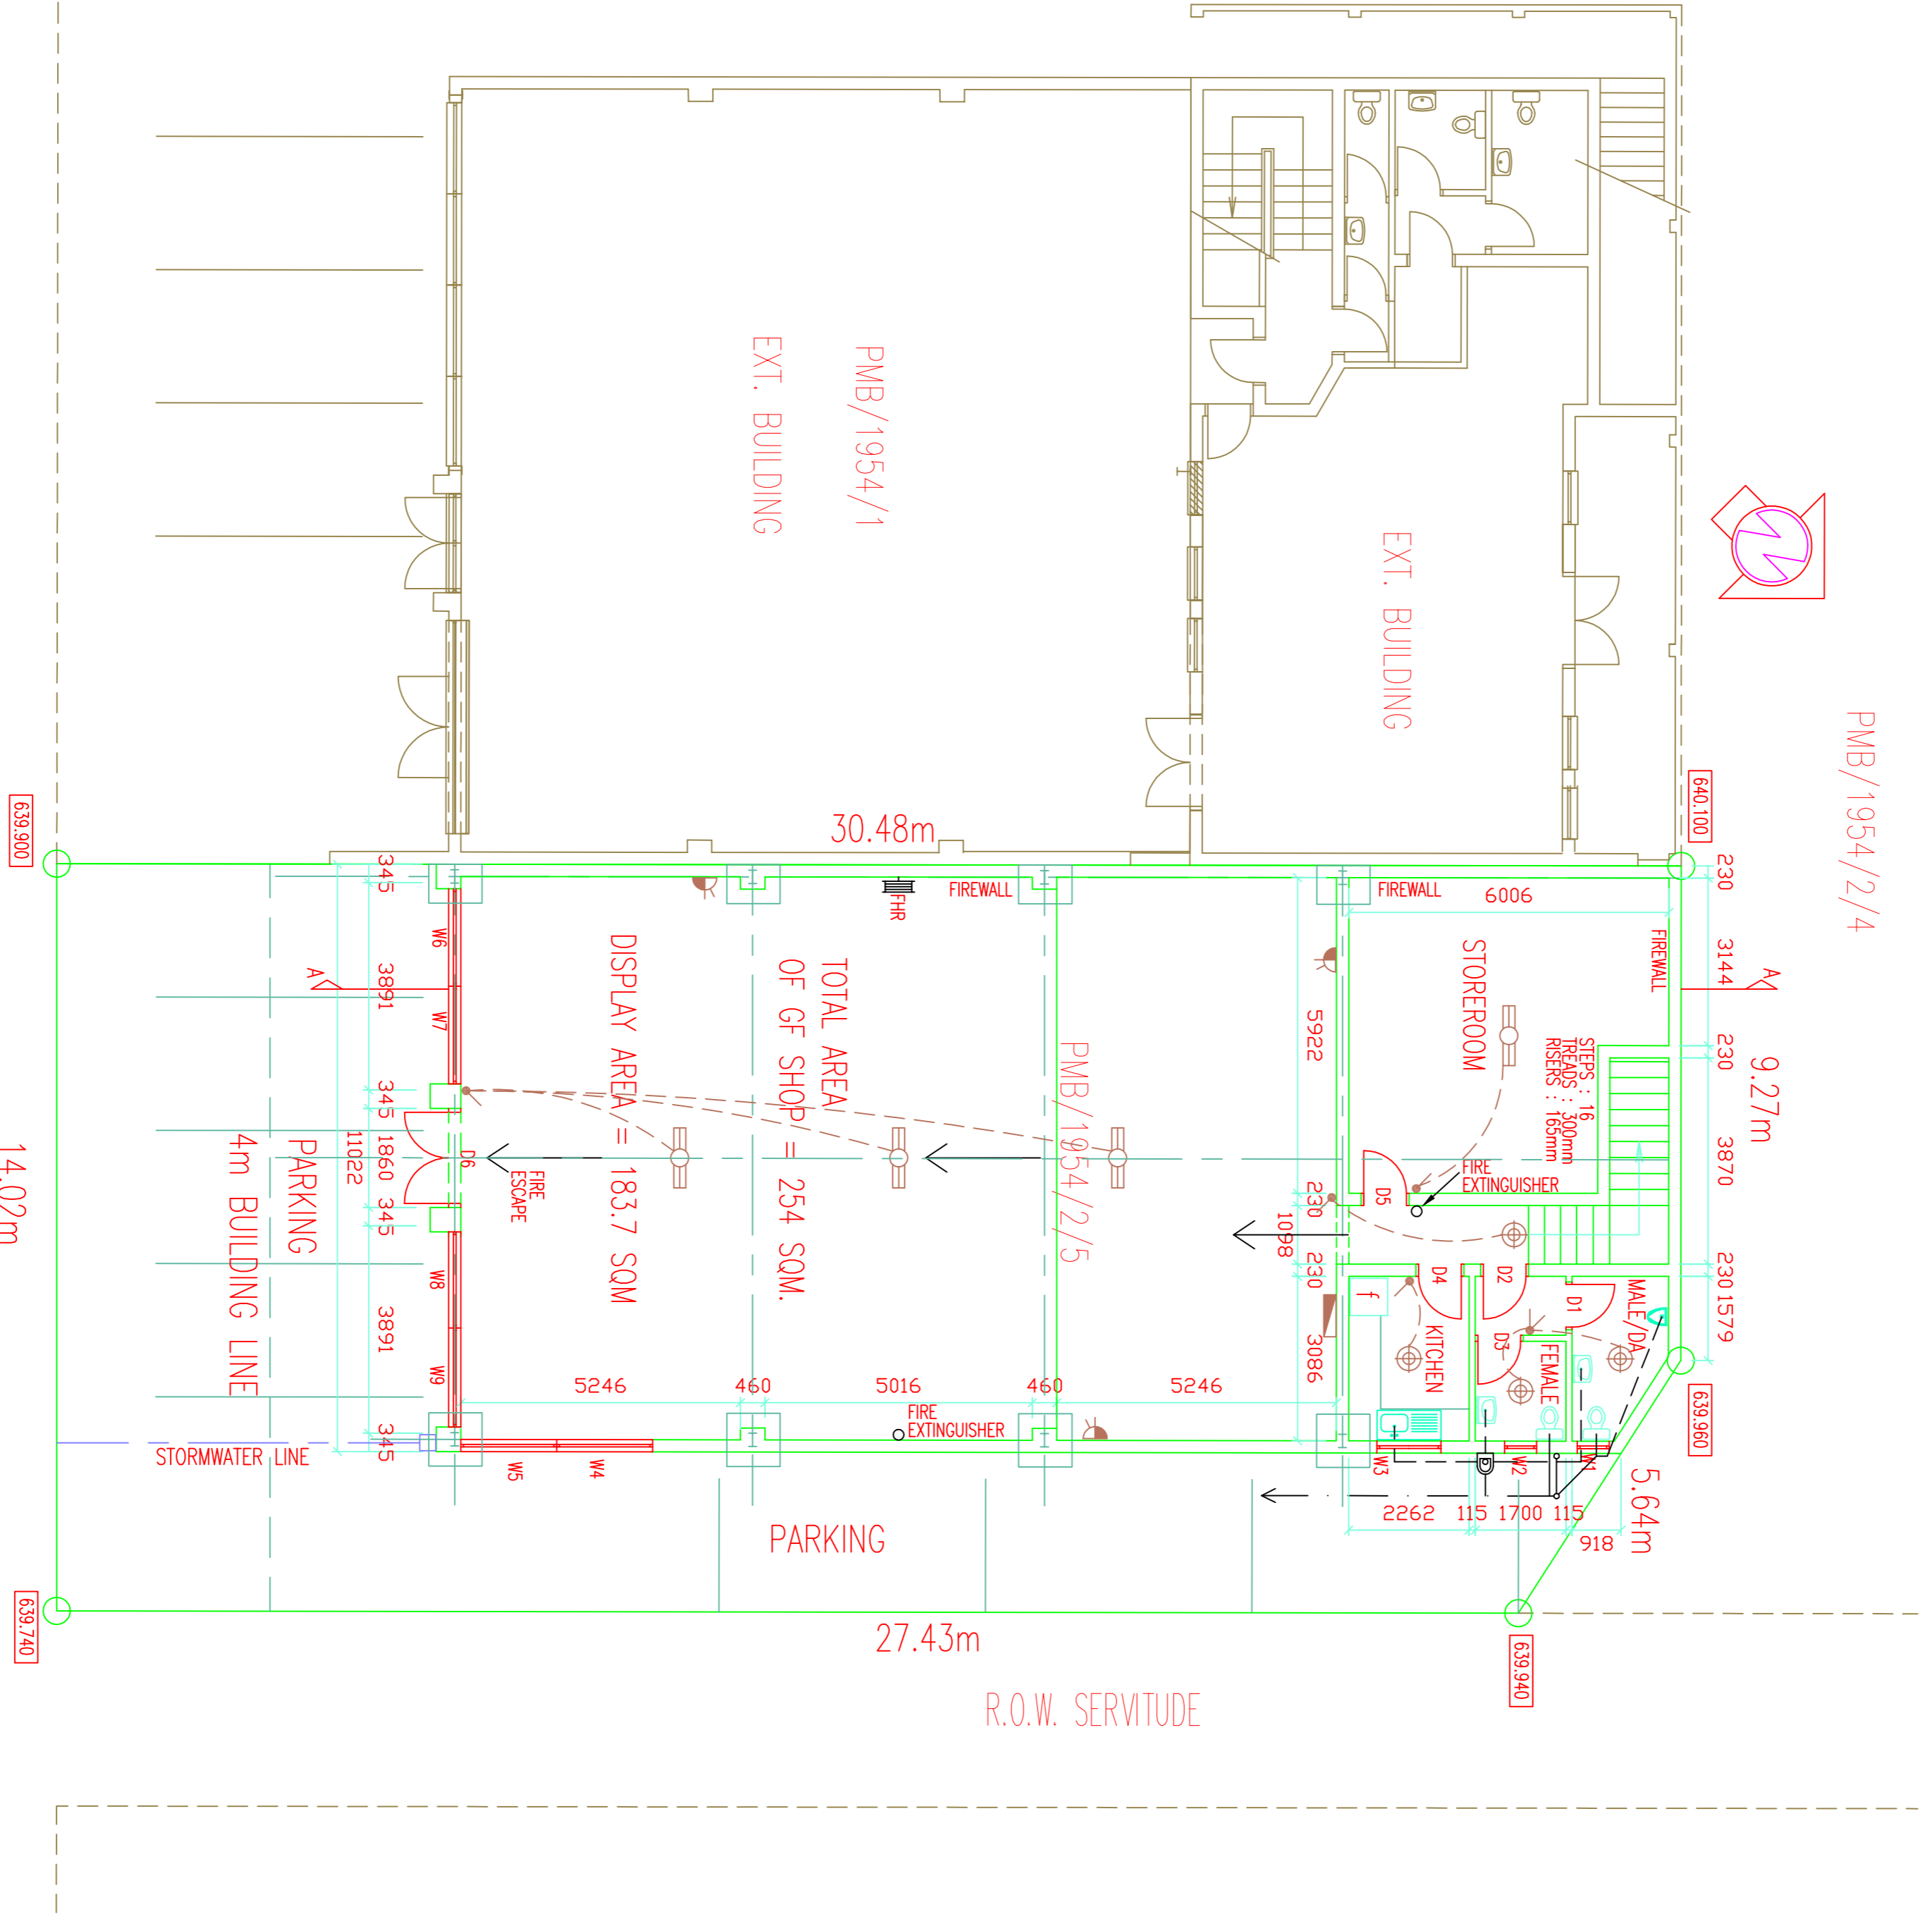


SKETCH PLAN DISCUSSION COPY ONLY

Electrical Legend table with symbols for Distribution Board, Ceiling Mounted Light Fitting, Telephone Connection, Double 15 Amp Plug-Point, and Light Switch.

Window & Door Schedule table listing specifications for various window and door types like W1, W2, W3, W10, W11, W12, W13, W14, W15, W16, W17, W18, W19, W20, D1, D2, D3, D4, D5, D6, D7, D8.

Window & Door Schedule table showing dimensions and details for windows and doors such as W10, W11, W12, W13, W14, W15, W16, W17, W18, W19, W20, D1, D2, D3, D4, D5, D6, D7, D8.

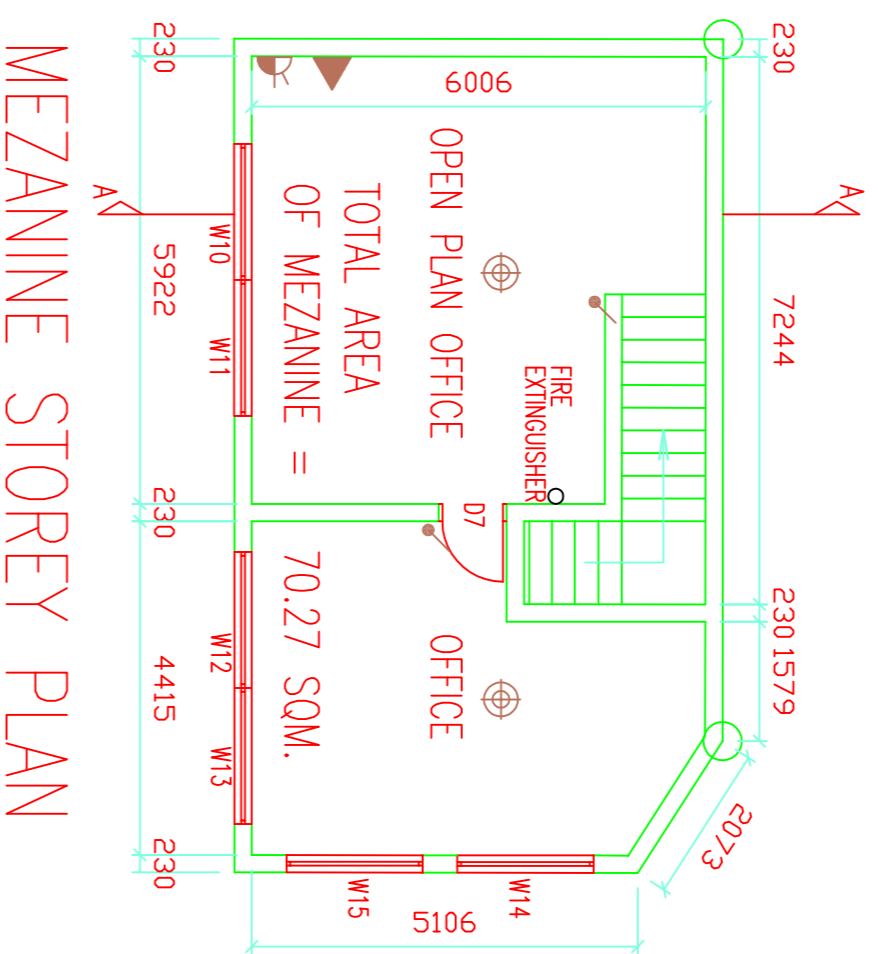

- GENERAL NOTES list of construction and safety requirements including fire protection, structural, and electrical specifications.

AREAS: GROUND STOREY = 254.36 sqm, MEZZANINE STOREY = 70.27 sqm, TOTAL AREA = 324.63 sqm, etc.

Designs logo and project information including author, architect, and registration details.

DATE: FEBRUARY 2014, DRAWING NO. 7 SHEET NO. 0000/01