


NOTE
ALL EXISTING PIPE TO BE TESTED
BEFORE CONNECTING.

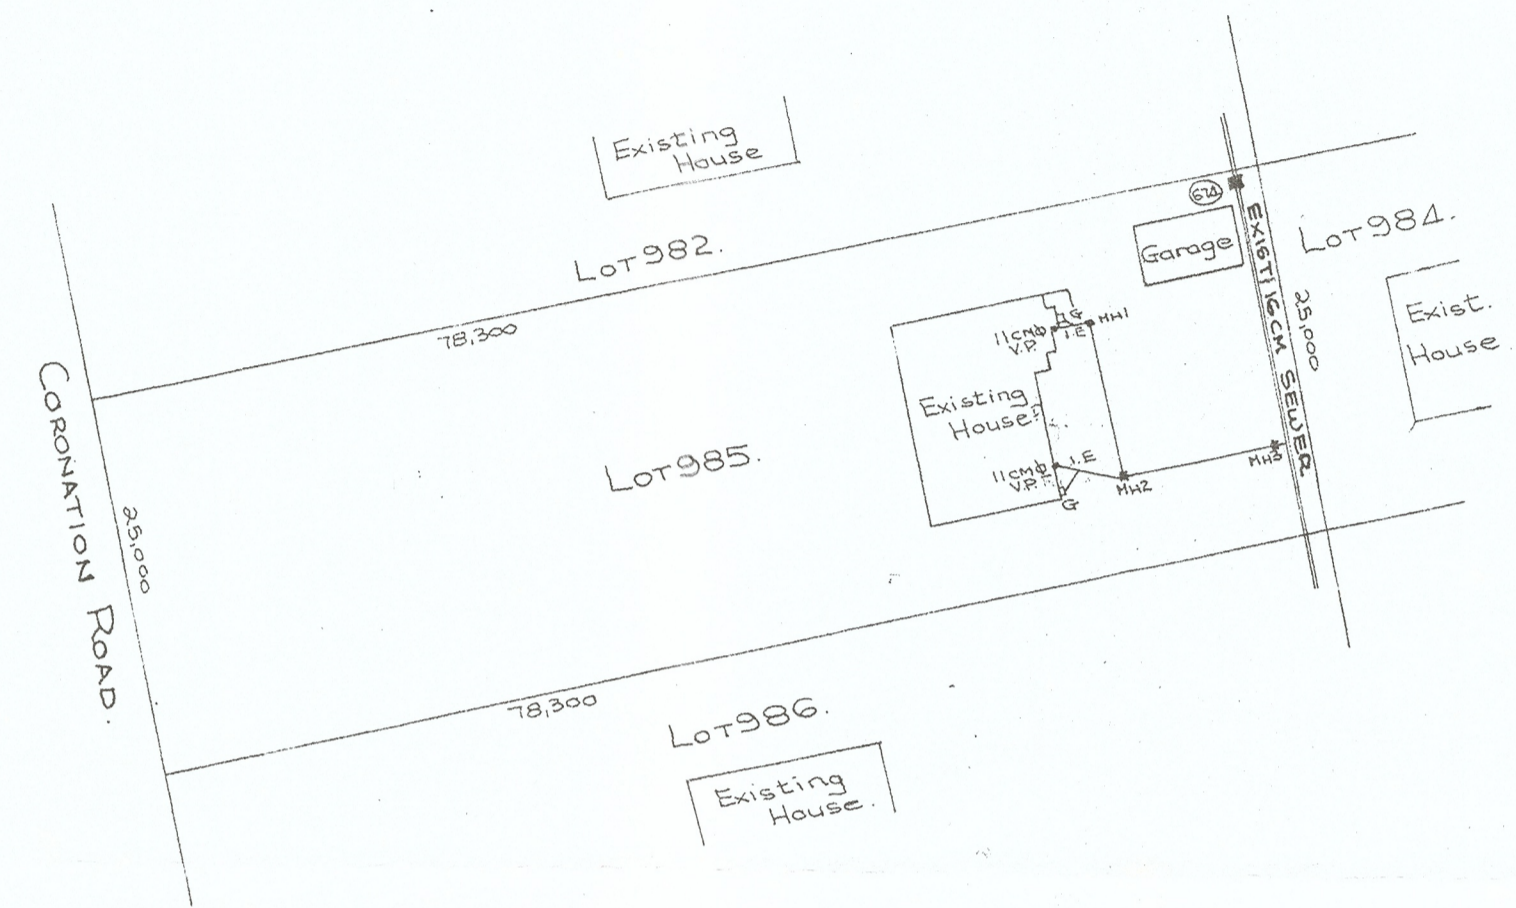

SITE PLAN:-
SCALE 1:500.

			EXISTING 18CM SEWER.	
			Exc MH1	MH2
				MH3
GRD LEVEL.	10,000	10,000	9,932.	8,912
INVERT LEVEL	9338	9,290	8,990	7,862
DIFF.	0,662	0,710	0,942	1,050
GRADE	1 IN 50	1 IN 34,00	1 IN 13,16	1 IN 35
CHAINAGE	2,400	10,400	10,400	1,200
MATERIAL.	Exc EWP.	PVC.	PVC.	CI

DRAWN BY:- *Sam Smith*
ADDRESS: 47 SALISBURY HOUSE
PHONE: 61204.

LOT 985 QUEENSBURGH TOWNSHIP.

PROPOSED DRAINAGE ~ A. BARRATT ESQ. 31 CORONATION ROAD, MLVN.

CONGREGATIONAL CHURCH
OF QUEENSBURGH
27 CORONATION ROAD
QUEENSBURGH 4093
POSTNET SUITE # 42
PRIVATE BAG 405
MALVERN
4055

SCALE: HORT - 1:250.
VERT - 1:125.