

- GENERAL DRAWING NOTES**
- THE DESIGN ON THIS DRAWING IS COPYRIGHT AND REMAINS THE PROPERTY OF THE ARCHITECTS.
 - ALL WORK TO BE CARRIED OUT STRICTLY IN ACCORDANCE WITH MUNICIPAL REGULATIONS.
 - DRAWINGS NOT TO BE SCALED, ONLY ANNOTATED DIMENSIONS TO BE USED.
 - ALL RELEVANT DATUM, LEVELS, DIMENSIONS TO BE CHECKED ON SITE BEFORE COMMENCEMENT OF WORK.
 - ALL DRAWINGS ARE TO BE CHECKED BY THE MAIN CONTRACTOR AND ANY DISCREPANCIES ON THE DRAWINGS OR BETWEEN THE DRAWINGS ARE TO BE REFERRED TO THE ARCHITECT.
 - CONTRACTOR TO CHECK ALL QUANTITIES PRIOR TO ORDERING AND MANUFACTURE.
 - CONTRACTOR TO PROVIDE SHOP DRAWINGS FOR APPROVAL BY ARCHITECT PRIOR TO MANUFACTURE.

Revision:	Date:	Description:
No.:	06/07/2021	Proposed brick area added, ex. demolished, General revision of annotations

Client: **UMGENI WATER · AMANZI**

Signature: *[Signature]* Date: _____

SAKHISIZWE ARCHITECTS
41 SWAPO ROAD, BROADWAY, DURBAN NORTH
TEL: 031 563 3424 FAX: 031 563 3518
www.sakhisizwearchitects.com

Project Title: **PROPOSED MAINTENANCE DRAWING FOR UMGENI WATER IN PIETERMARITZBURG**

Professional Architects signature: *[Signature]*
Mr K.P. Mawesane (Pr. Arch) satep (7982) sala (7593)

Date: **JAN 2020** Scale: **As Indicated**

Drawn: **KN**


Drawing Description: **PLAN, ELEVATIONS and ELECTRICAL LAYOUT**

Job no.:	Drawing no.:	Rev. no.:
s499	IN/AD01/ARCH/CL00014/0002	01


ISSUED FOR APPROVAL

ISSUED FOR SUBMISSION


ISSUED FOR TENDER

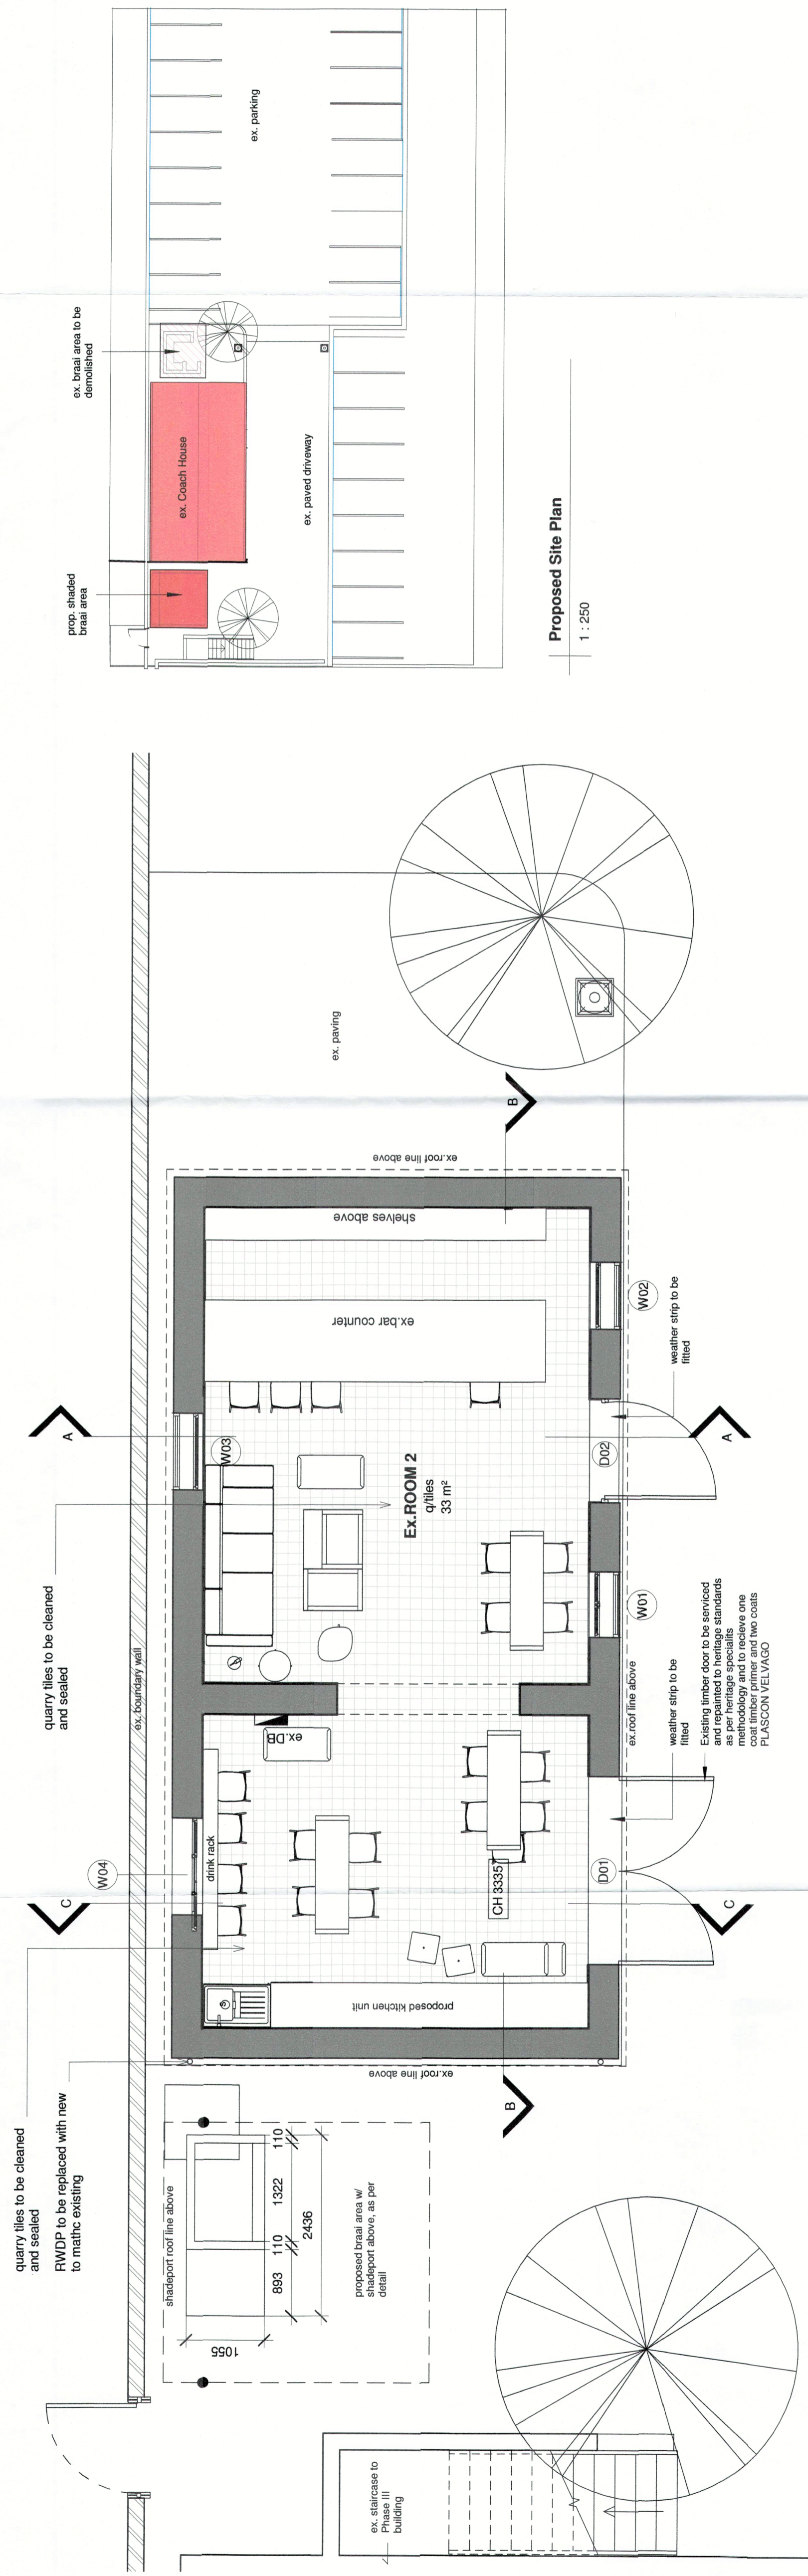

GROUND FLOOR STOREY RESTORATION
1 : 50

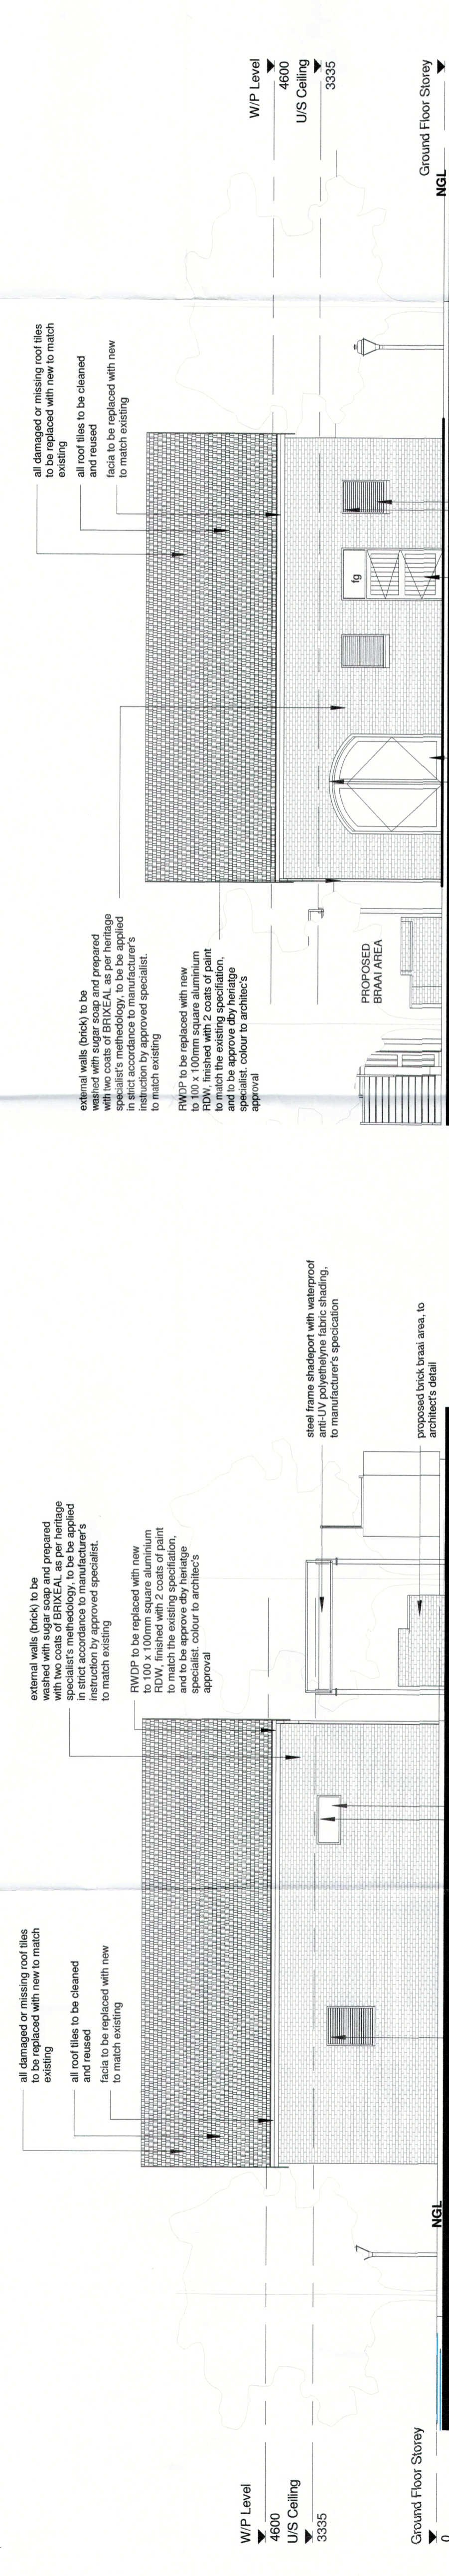

NORTH ELEVATION RESTORATION
1 : 100

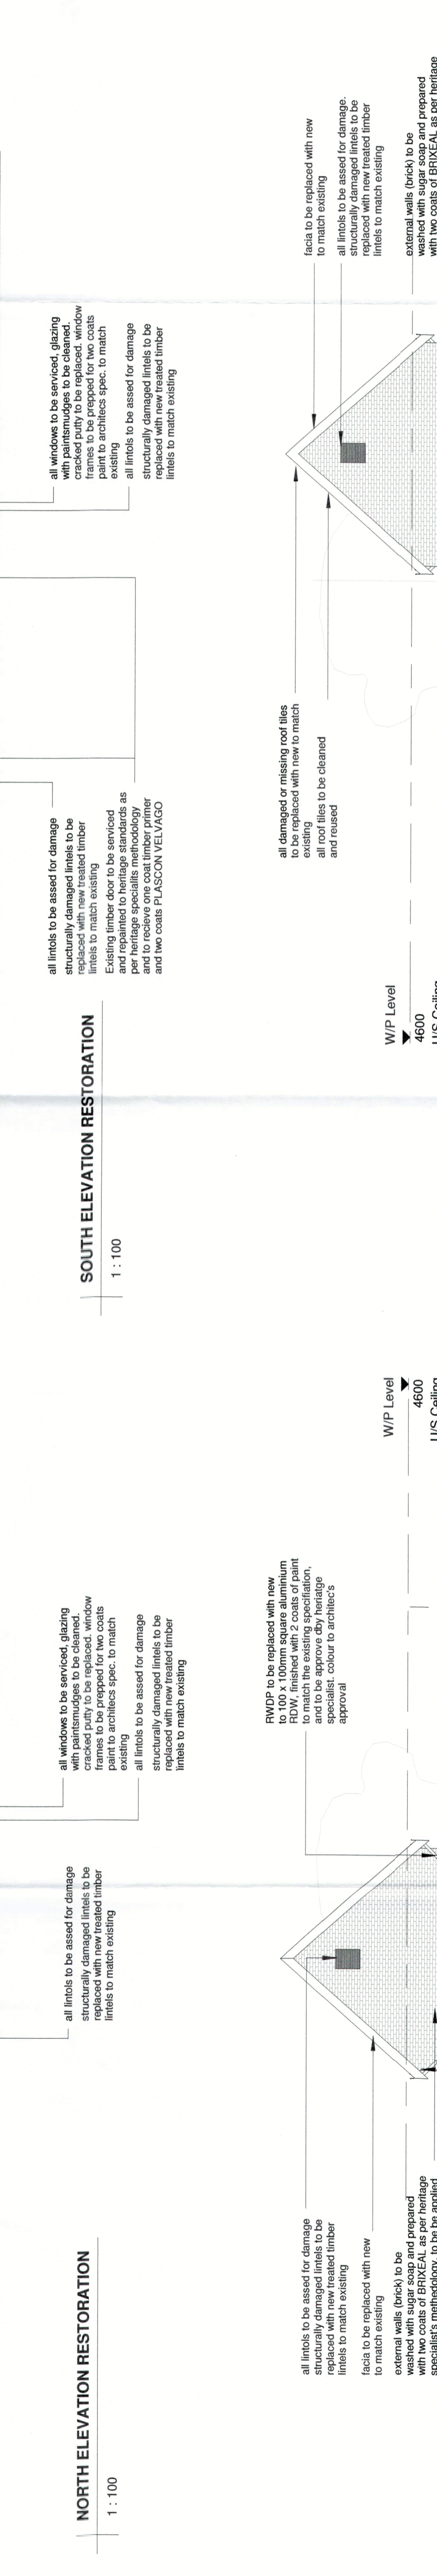

SOUTH ELEVATION RESTORATION
1 : 100



WEST ELEVATION RESTORATION
1 : 100

EAST ELEVATION RESTORATION
1 : 100