

Required Dept. of Health Signatures

FACILITY MANAGER

DISTRICT MANAGER

AREA MANAGER

NO: DATE: BY: DESCRIPTION:

REVISIONS:

Checked by Consultant


Name

signature date

Consultant

Architect

GRICE BELLARS, Architects
 211 Hoosen Haffjee St. PMB
 033 394 1785

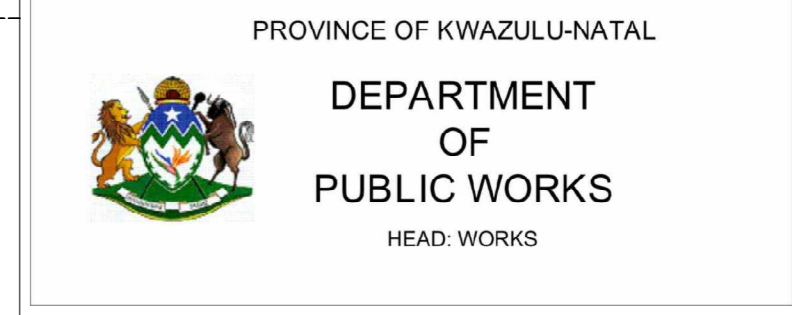

Project

CONVERSION OF BOYS MODEL SCHOOL TO OFFICES FOR DEPT. OF HEALTH
 30 JABU NDLOVU STREET

Drawing Title

WORKING DRAWING
 SITE PLAN

Scale 1:250 Date DEC 2002 Drawn NCG

Consultant Drawing Number BM-WD-01 Revision A

DOW Drawing Number WIMS NO 052393/ Revision

Stamped by Plans Approval Committee



LOCALITY PLAN OF CENTRAL PIETERMARITZBURG