


Required Dept. of Health Signatures

FACILITY MANAGER

DISTRICT MANAGER

AREA MANAGER

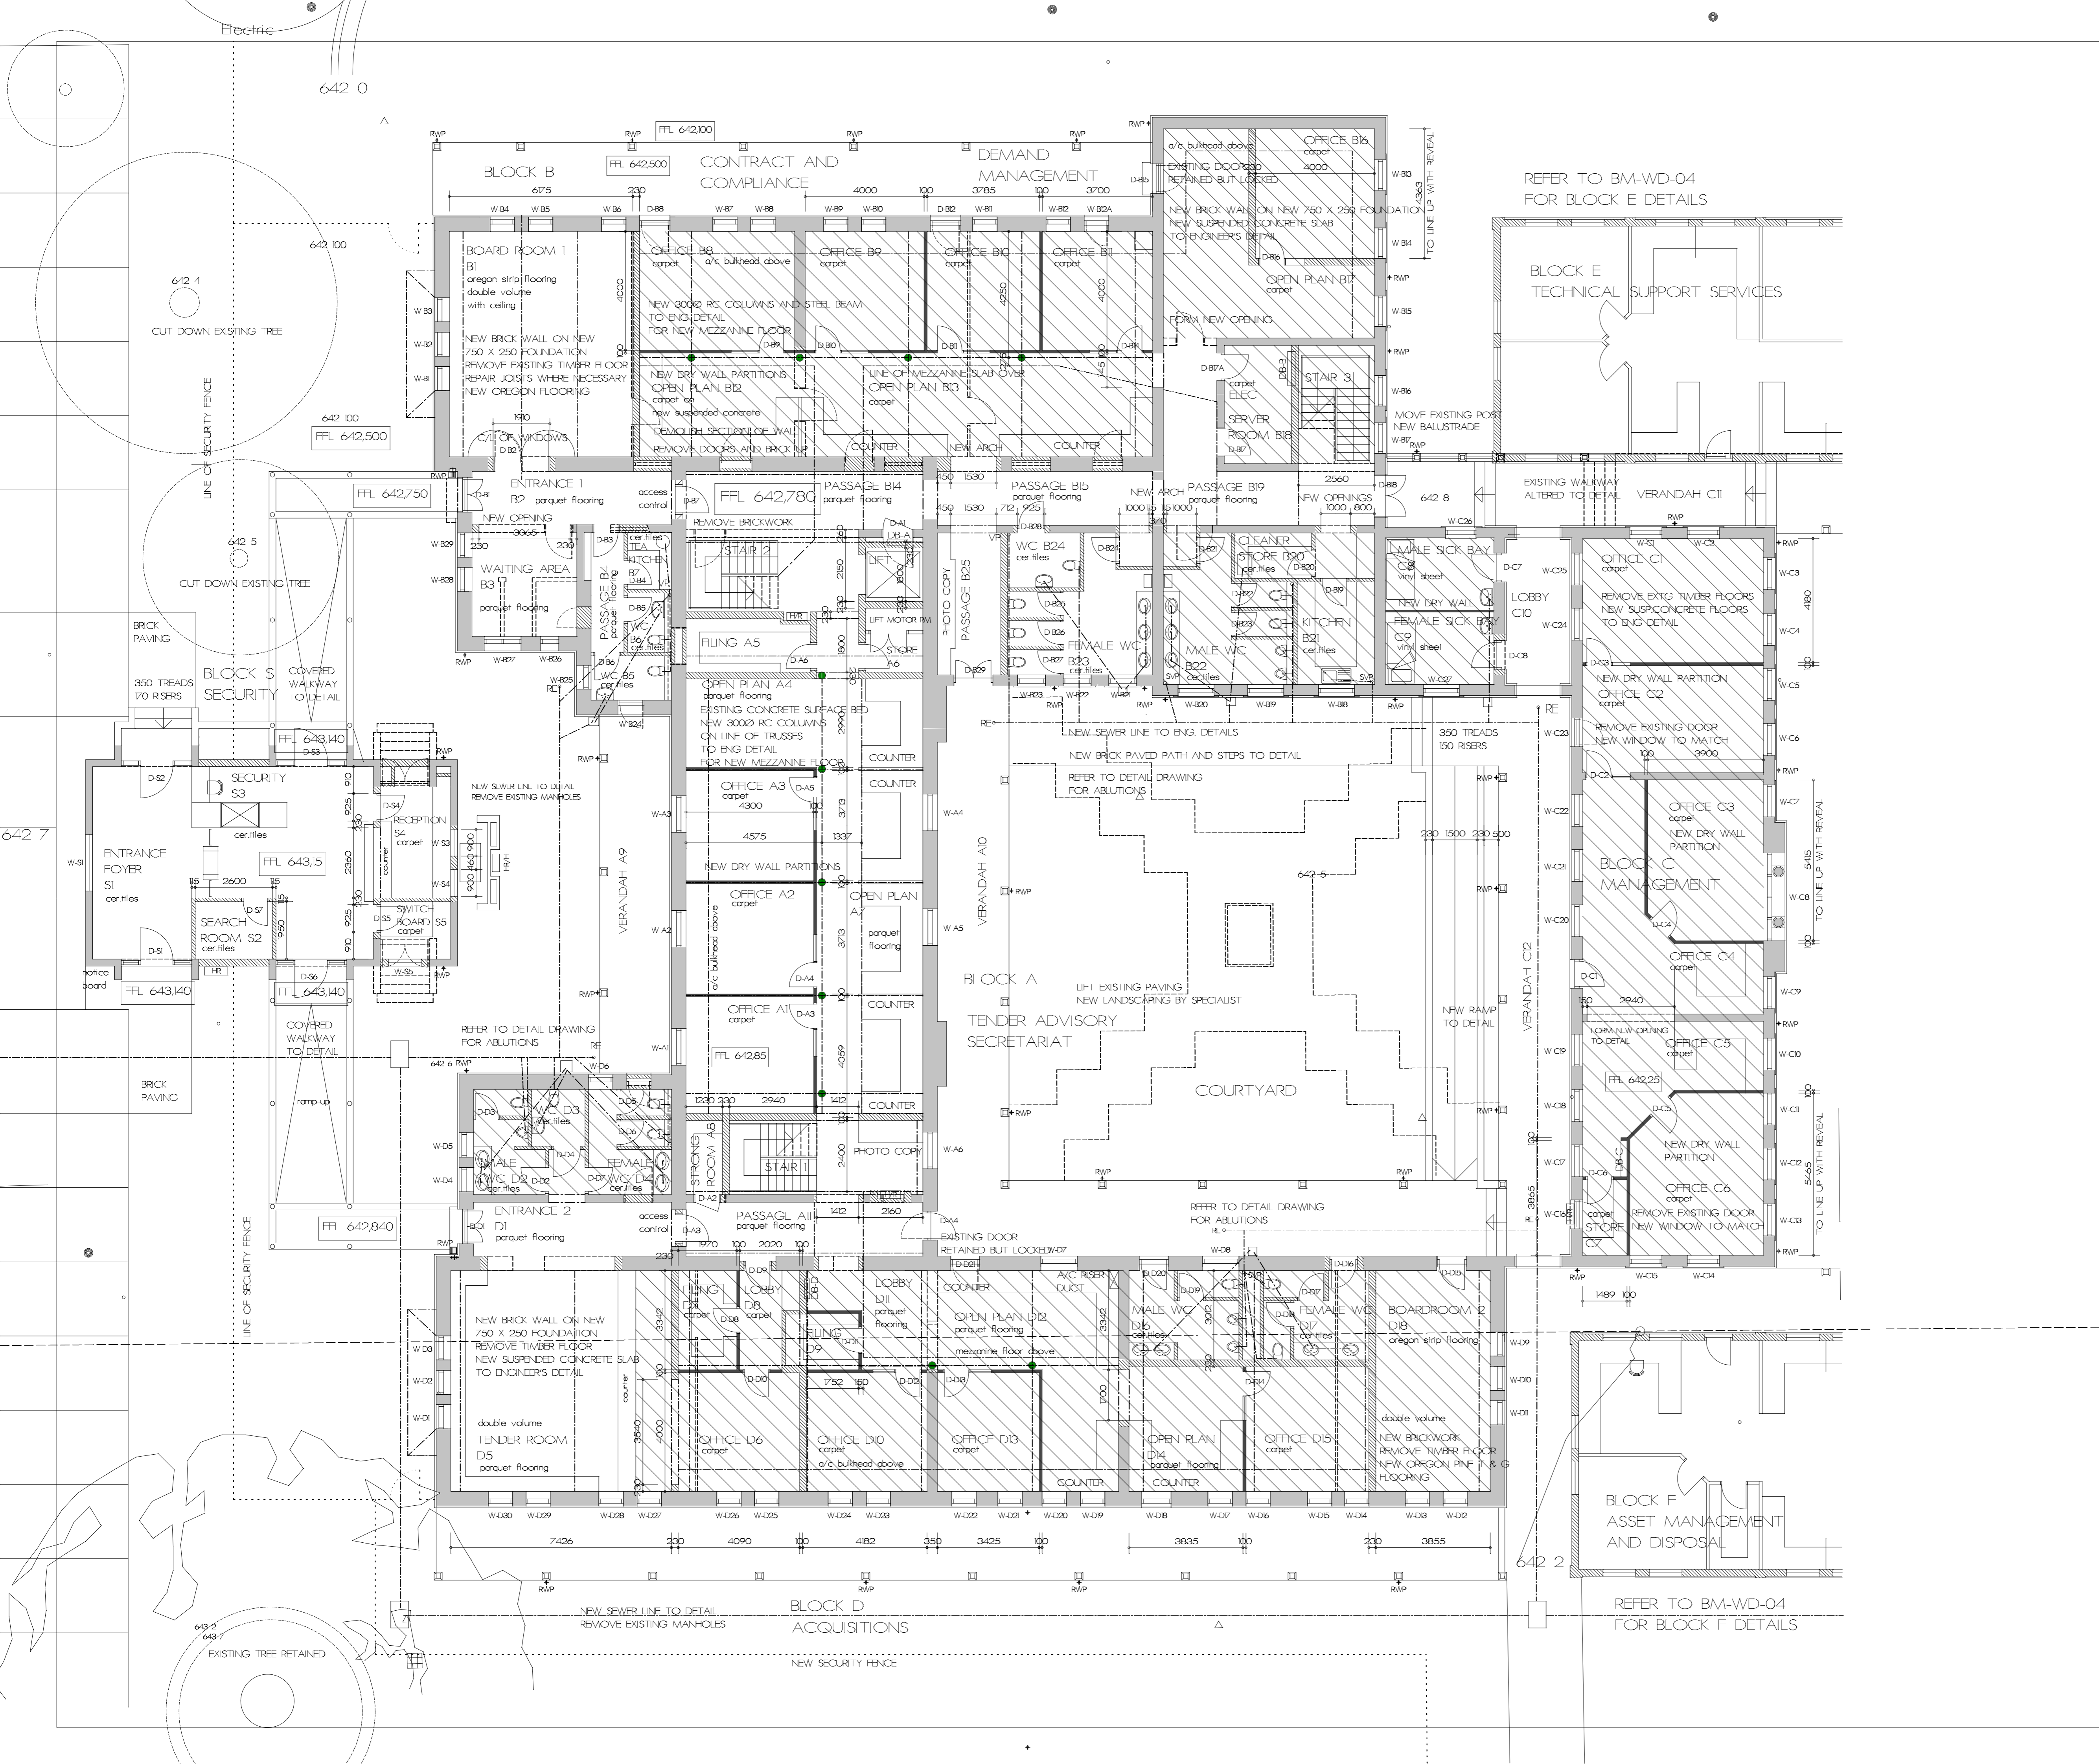

B	958	NG	LIFT SHAFT MOVED, BLOCK A BRWK AMENDED
NO :	DATE :	BY :	DESCRIPTION :

REVISIONS

Checked by Consultant Name

signature date

Consultant

Architect
GRICE BELLARS, Architects
 211 Hoosen Haffjee St. PMB
 033 394 1785



Project
CONVERSION OF BOYS MODEL SCHOOL TO OFFICES FOR DEPT. OF HEALTH

Drawing Title
WORKING DRAWING GROUND FLOOR PLAN - BLOCKS A-D

Scale 1:100	Date DEC 2012	Drawn MCG
Consultant Drawing Number BM-WD-02	Revision B	
DOW Drawing Number WIMS NO 052393/	Revision	

Stamped by Plans Approval Committee