



Required Dept. of Health Signatures

FACILITY MANAGER

DISTRICT MANAGER

AREA MANAGER

NO : DATE : BY : DESCRIPTION :


REVISIONS:

Checked by Consultant Name

signature date

Consultant

Architect
GRICE BELLARS, Architects
 211 Hoosen Haffjee St. PMB
 033 394 1785

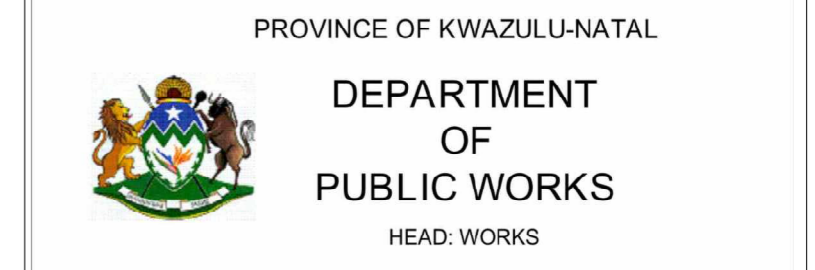

Project
CONVERSION OF BOYS MODEL SCHOOL TO OFFICES FOR DEPT. OF HEALTH

Drawing Title
**WORKING DRAWING
 GROUND FLOOR PLAN - BLOCKS E, C, F**

Scale 1:100 Date DEC 2012 Drawn NCG

Consultant Drawing Number BM-WD-04 Revision A

DOW Drawing Number WIMS NO 052393/ Revision

Stamped by Plans Approval Committee